



NOTES:
 These plans are not to be reproduced or reused without the written permission of J. THACKER
 CUSTOM HOME DESIGNS
 SUITE 210, HURST, TX 76053
 817-282-0654
 It is the responsibility of the contractor to verify all dimensions, codes and easements. Designer's liability not to exceed the bid for plans.

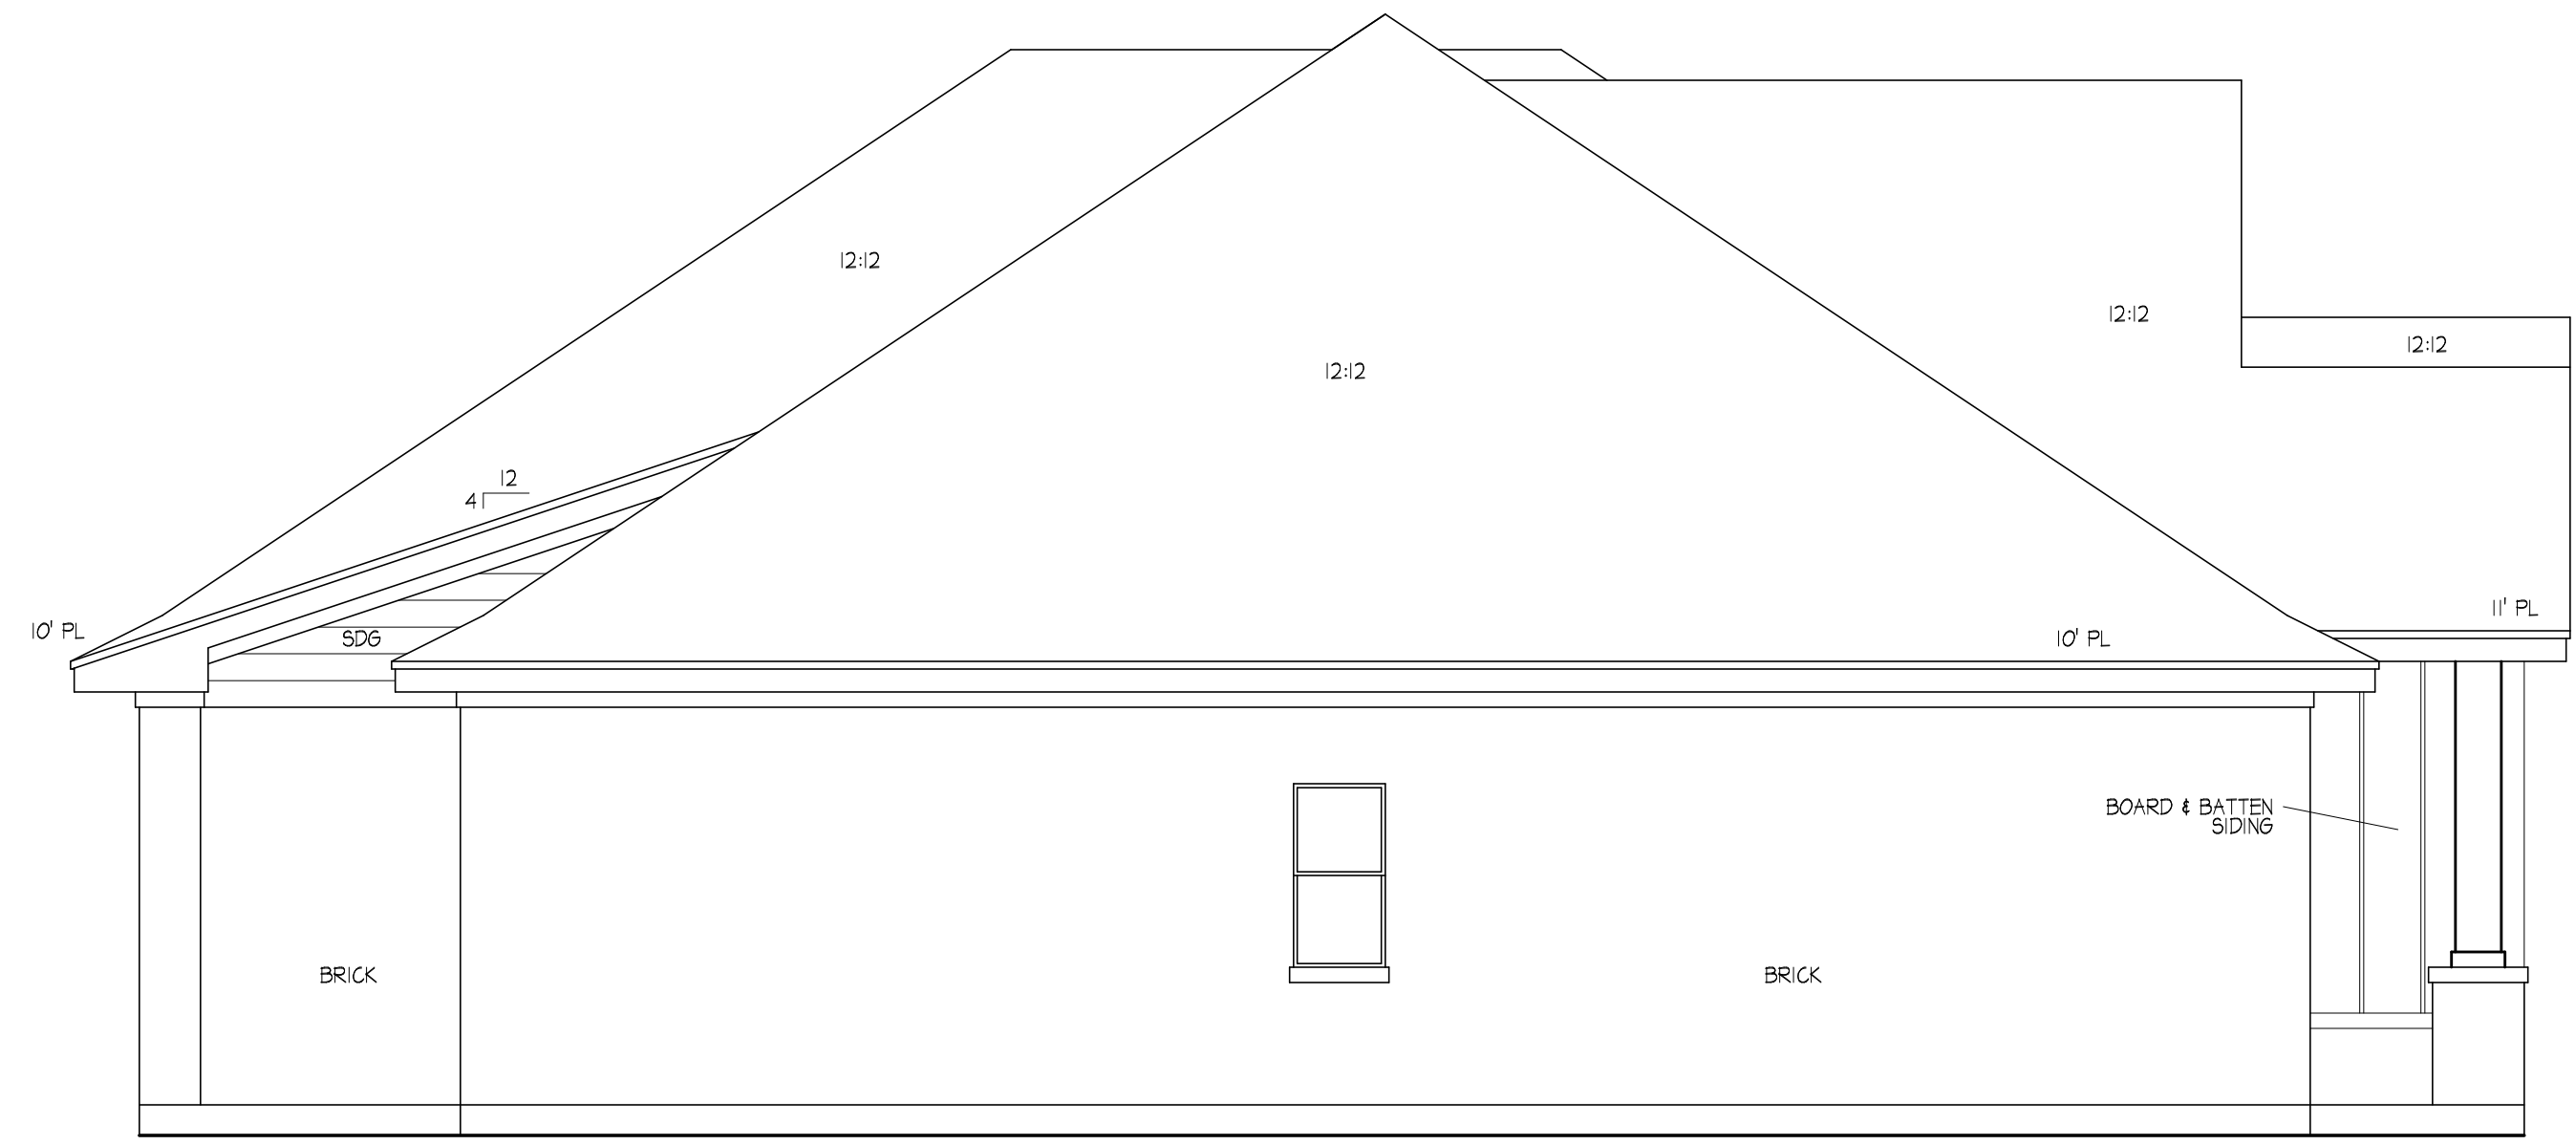

LEFT SIDE

SC:1/4"=1'-0"

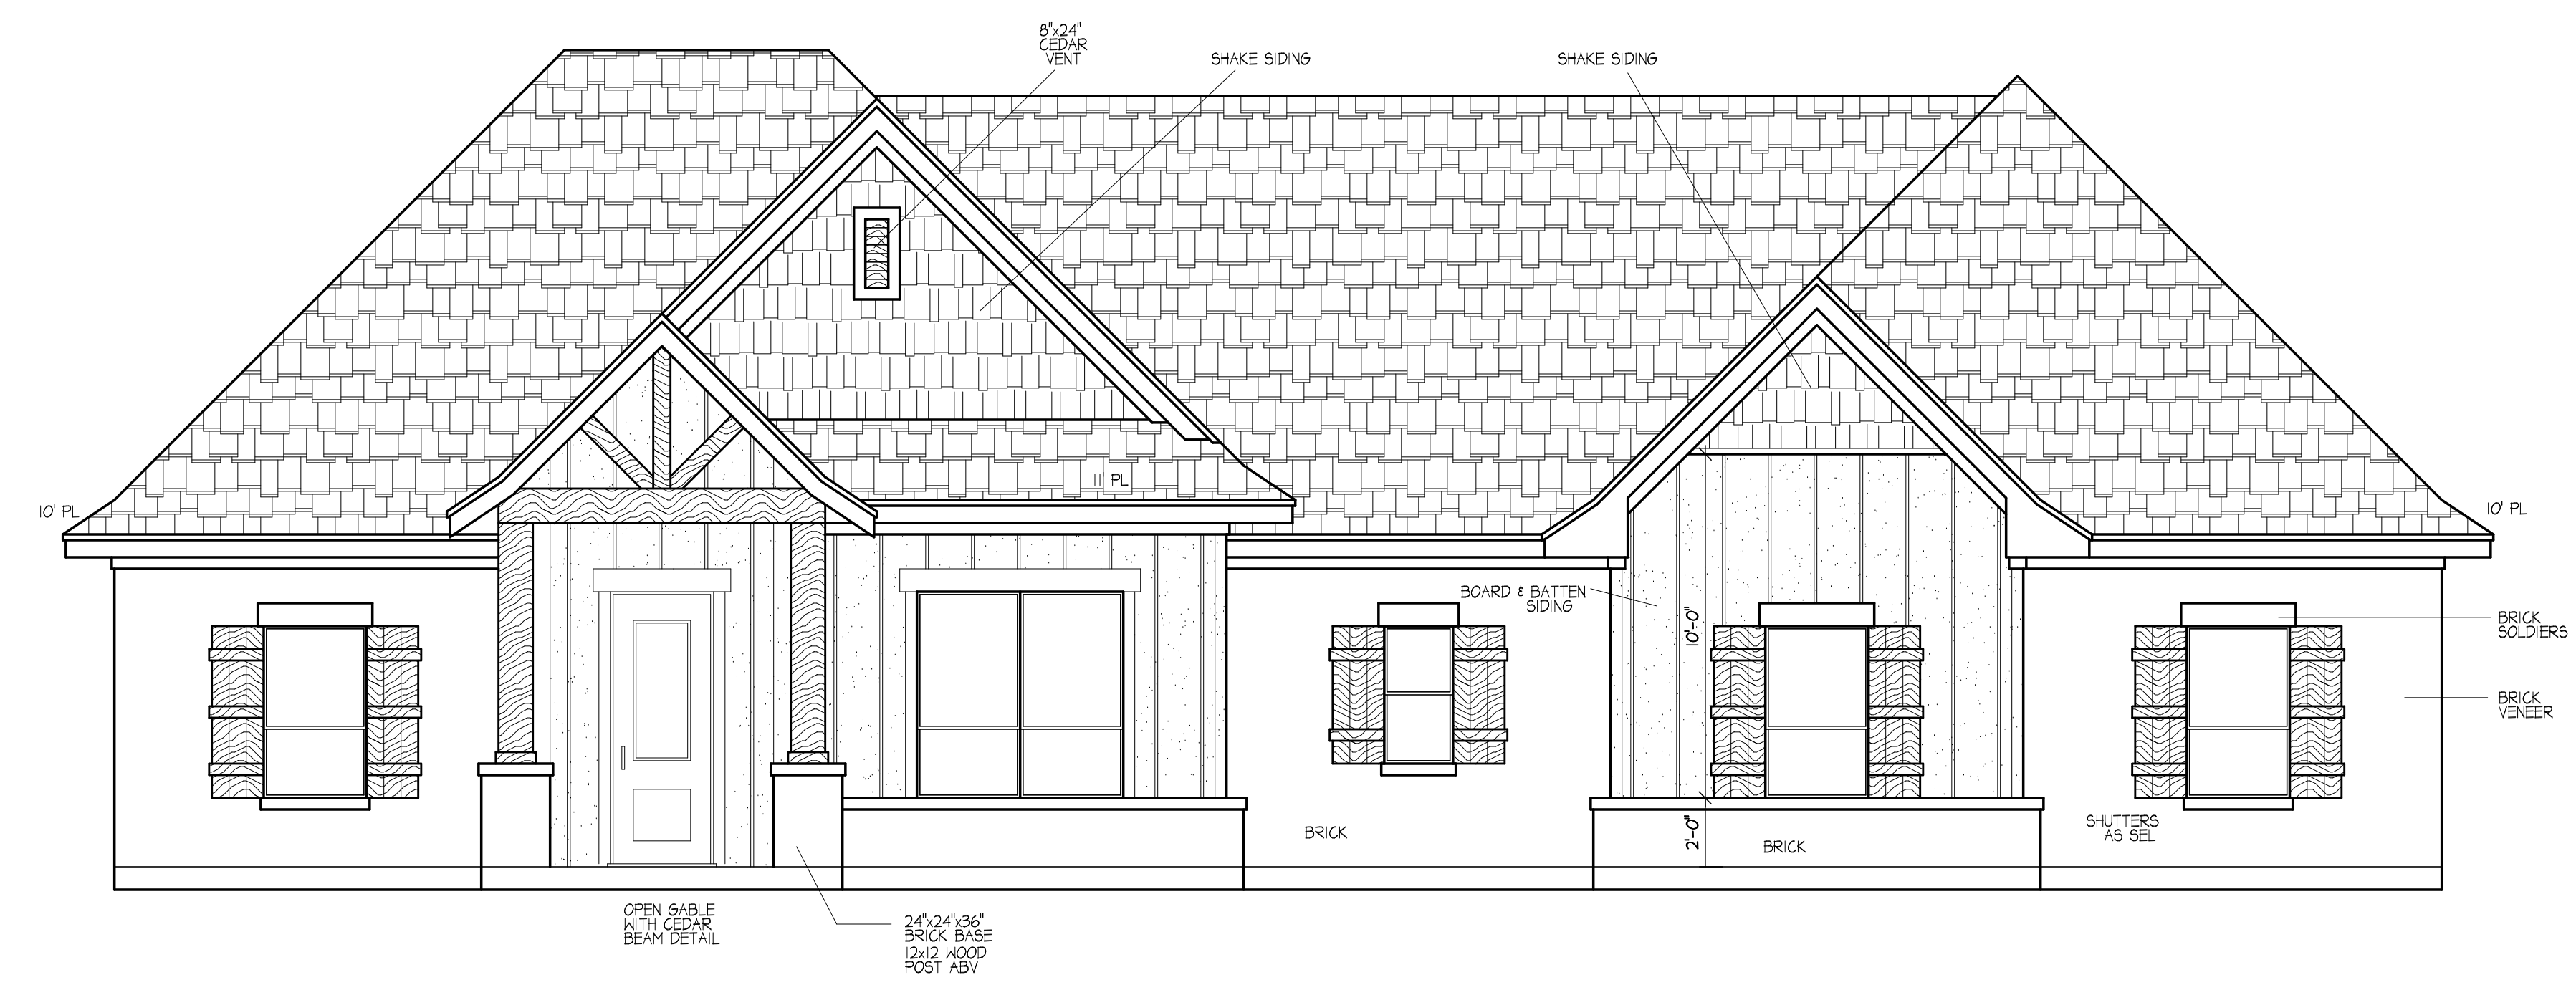


FRONT ELEVATION

SC:1/4"=1'-0"

R T B
 CUSTOM HOMES
 817-901-7963


1245 HURSTVIEW DRIVE
 SUITE 210, HURST, TX 76053
 817-282-0654

PLAN NO.
 03212201

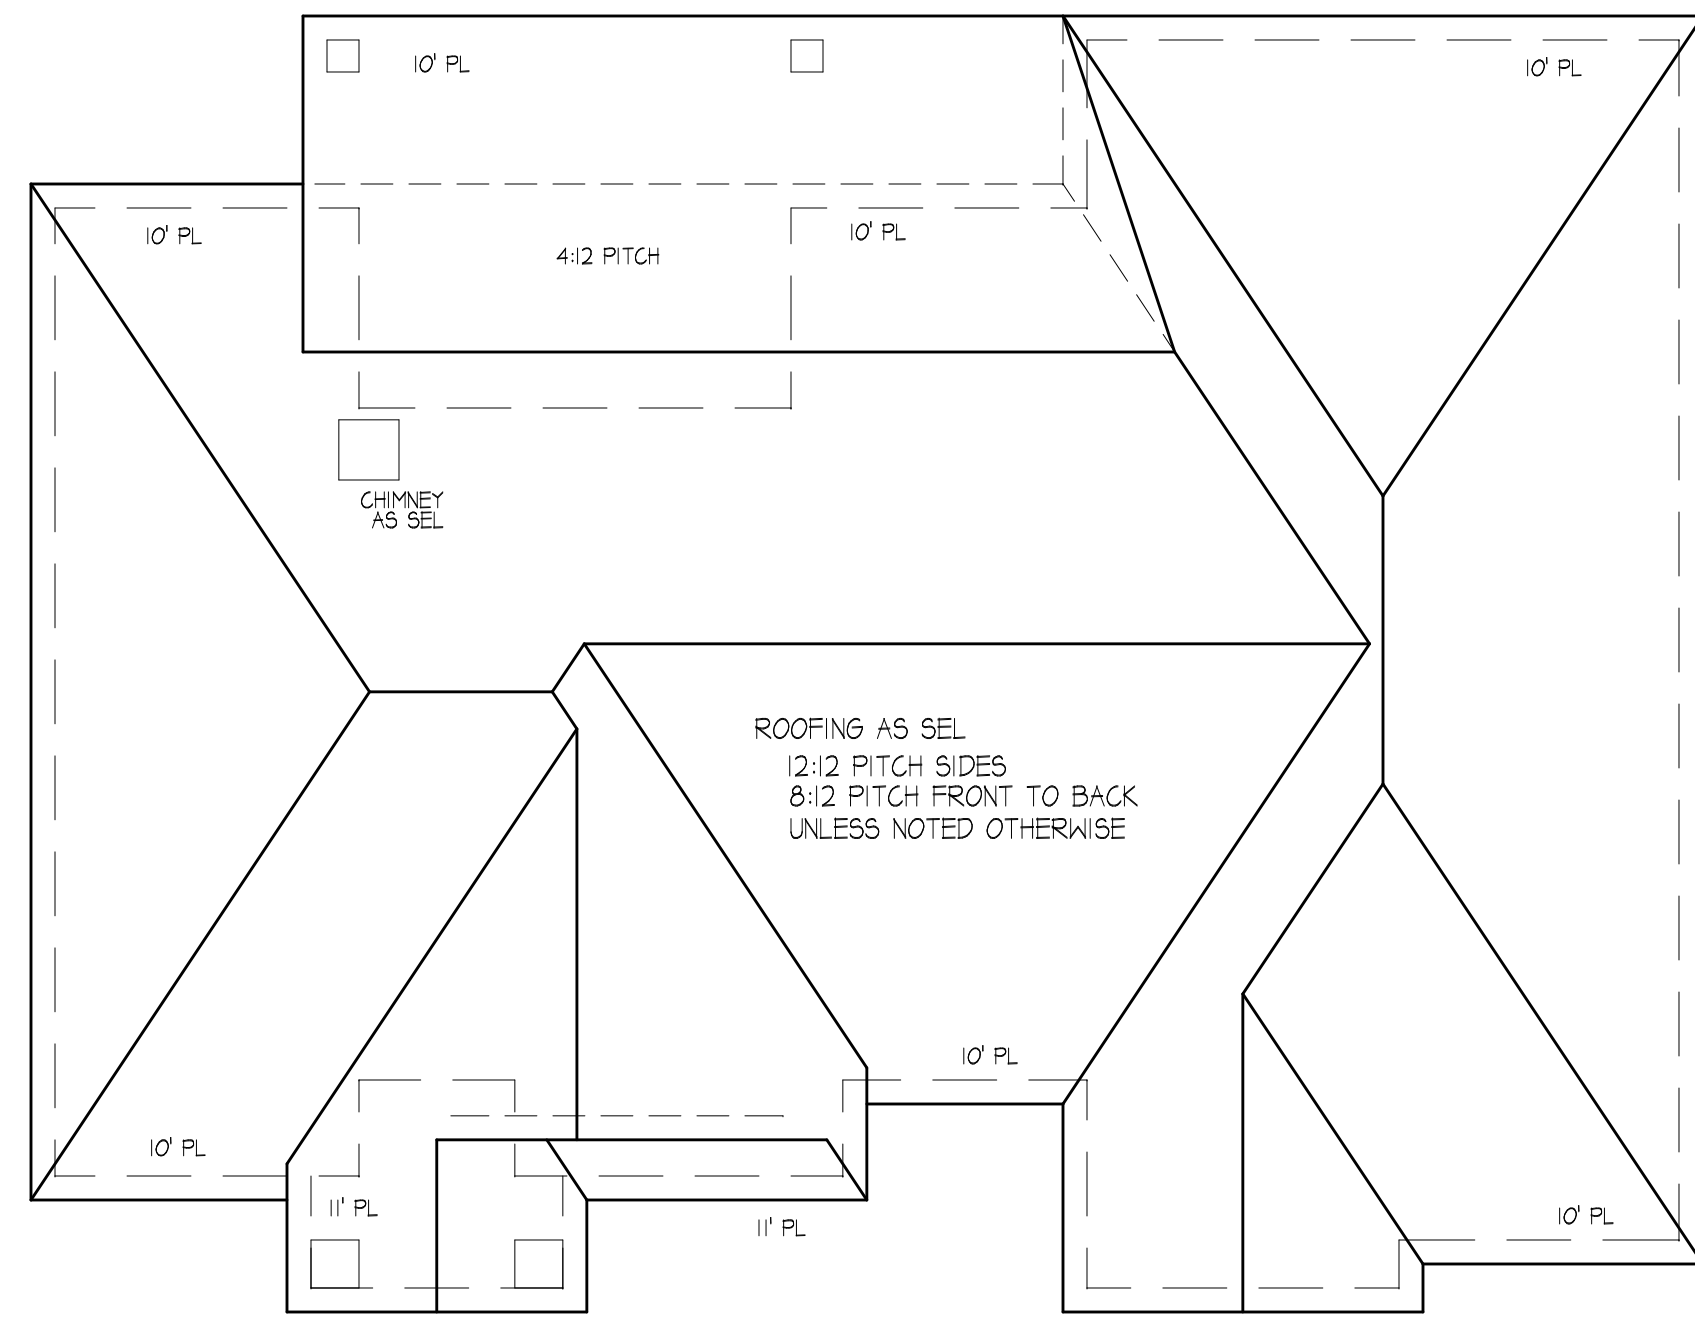


ROOF PLAN

SCALE: 1/8"=1'-0"

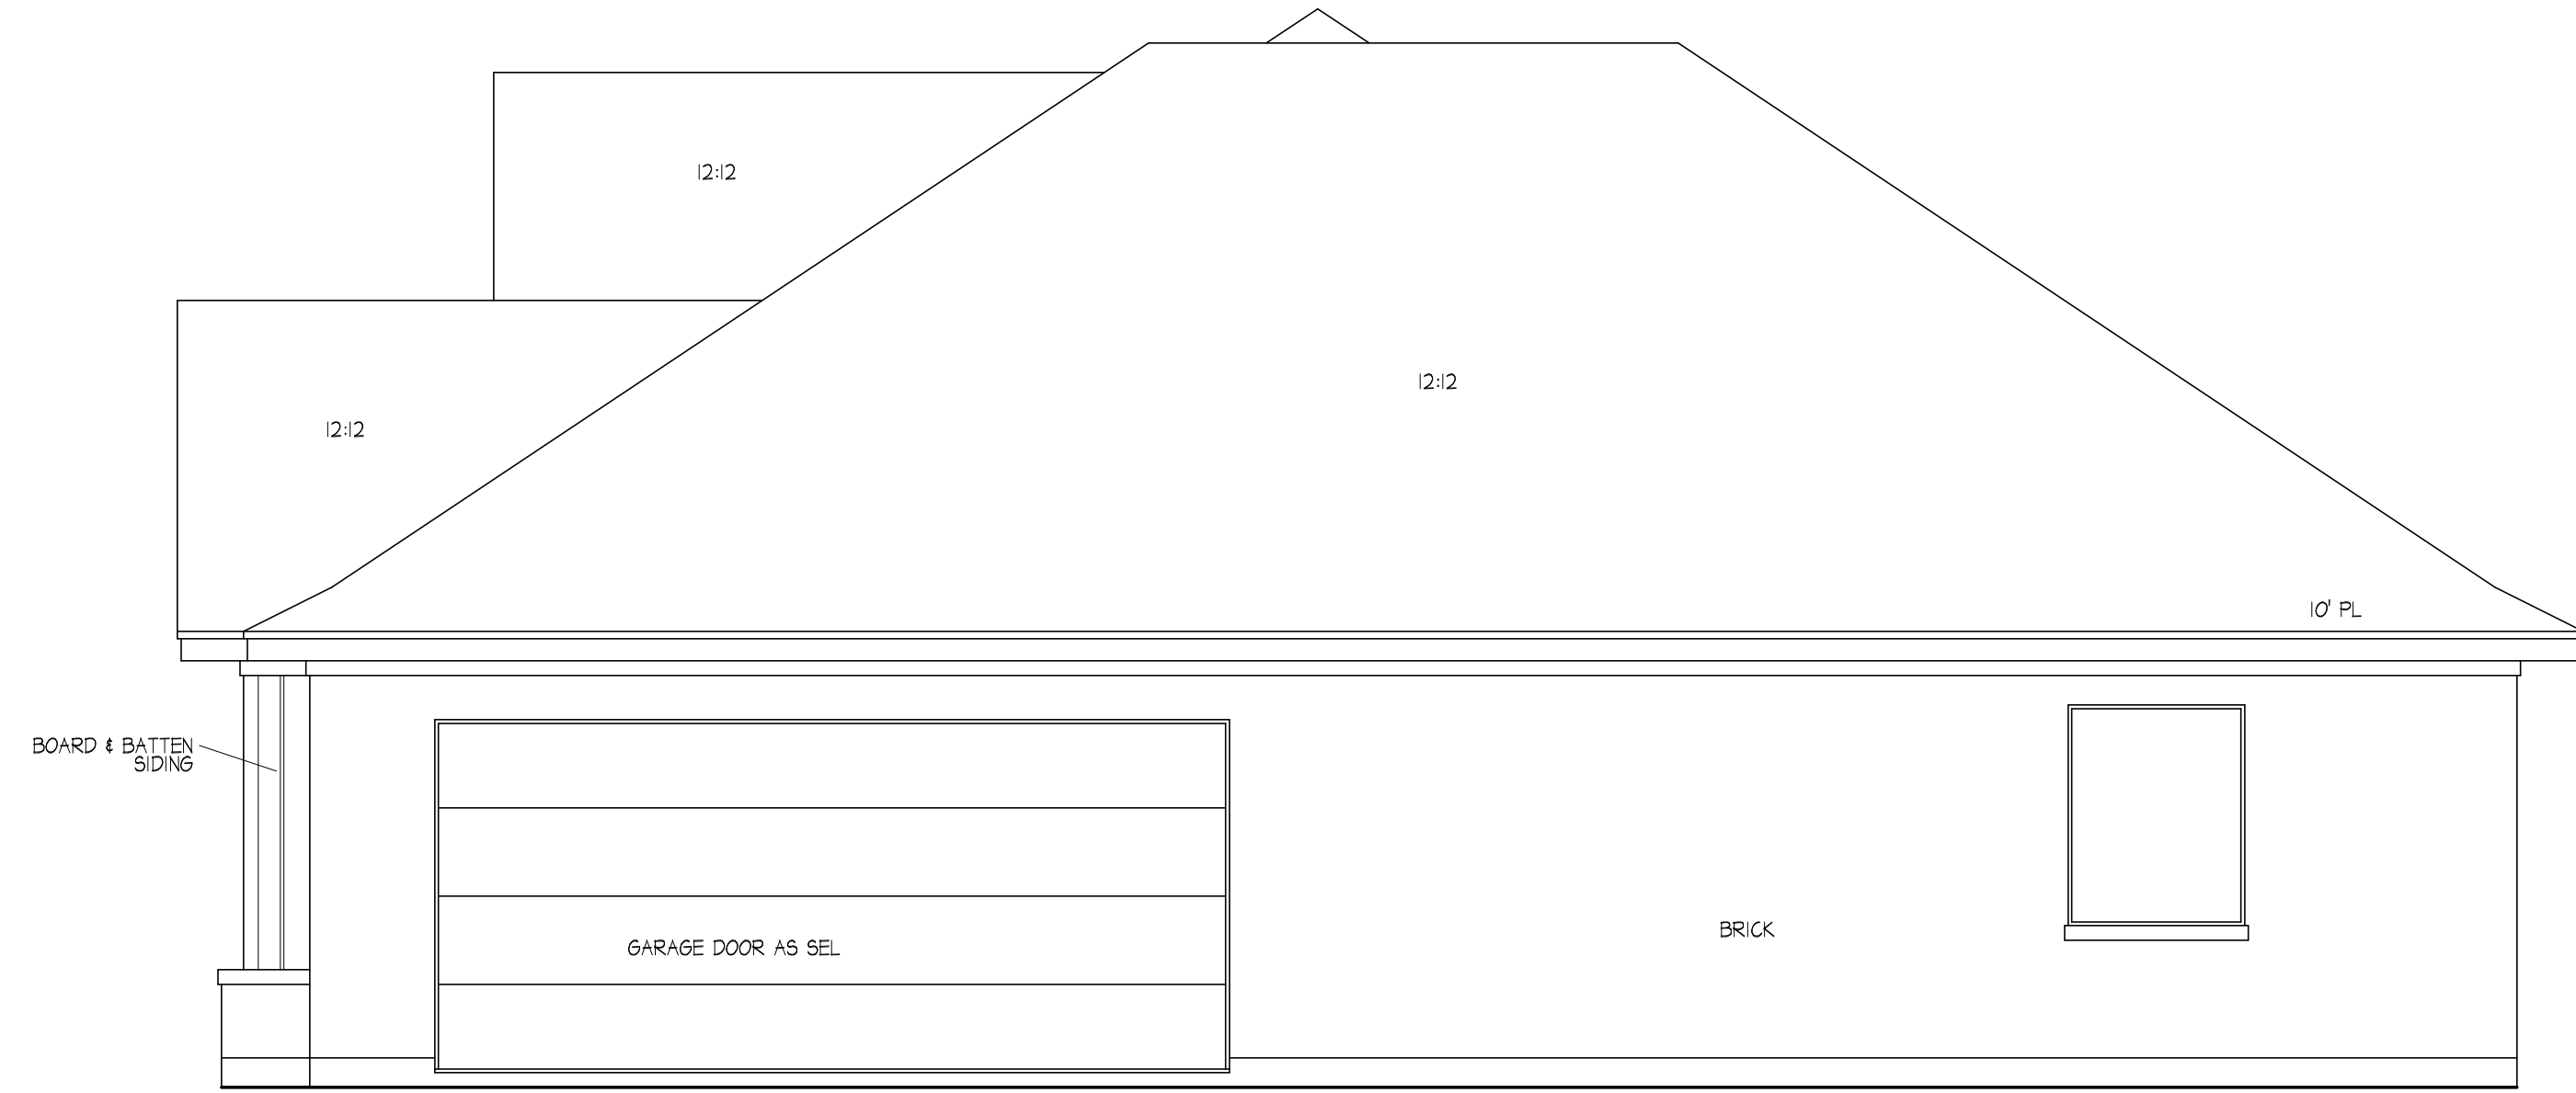

RIGHT SIDE

SCALE: 1/4"=1'-0"

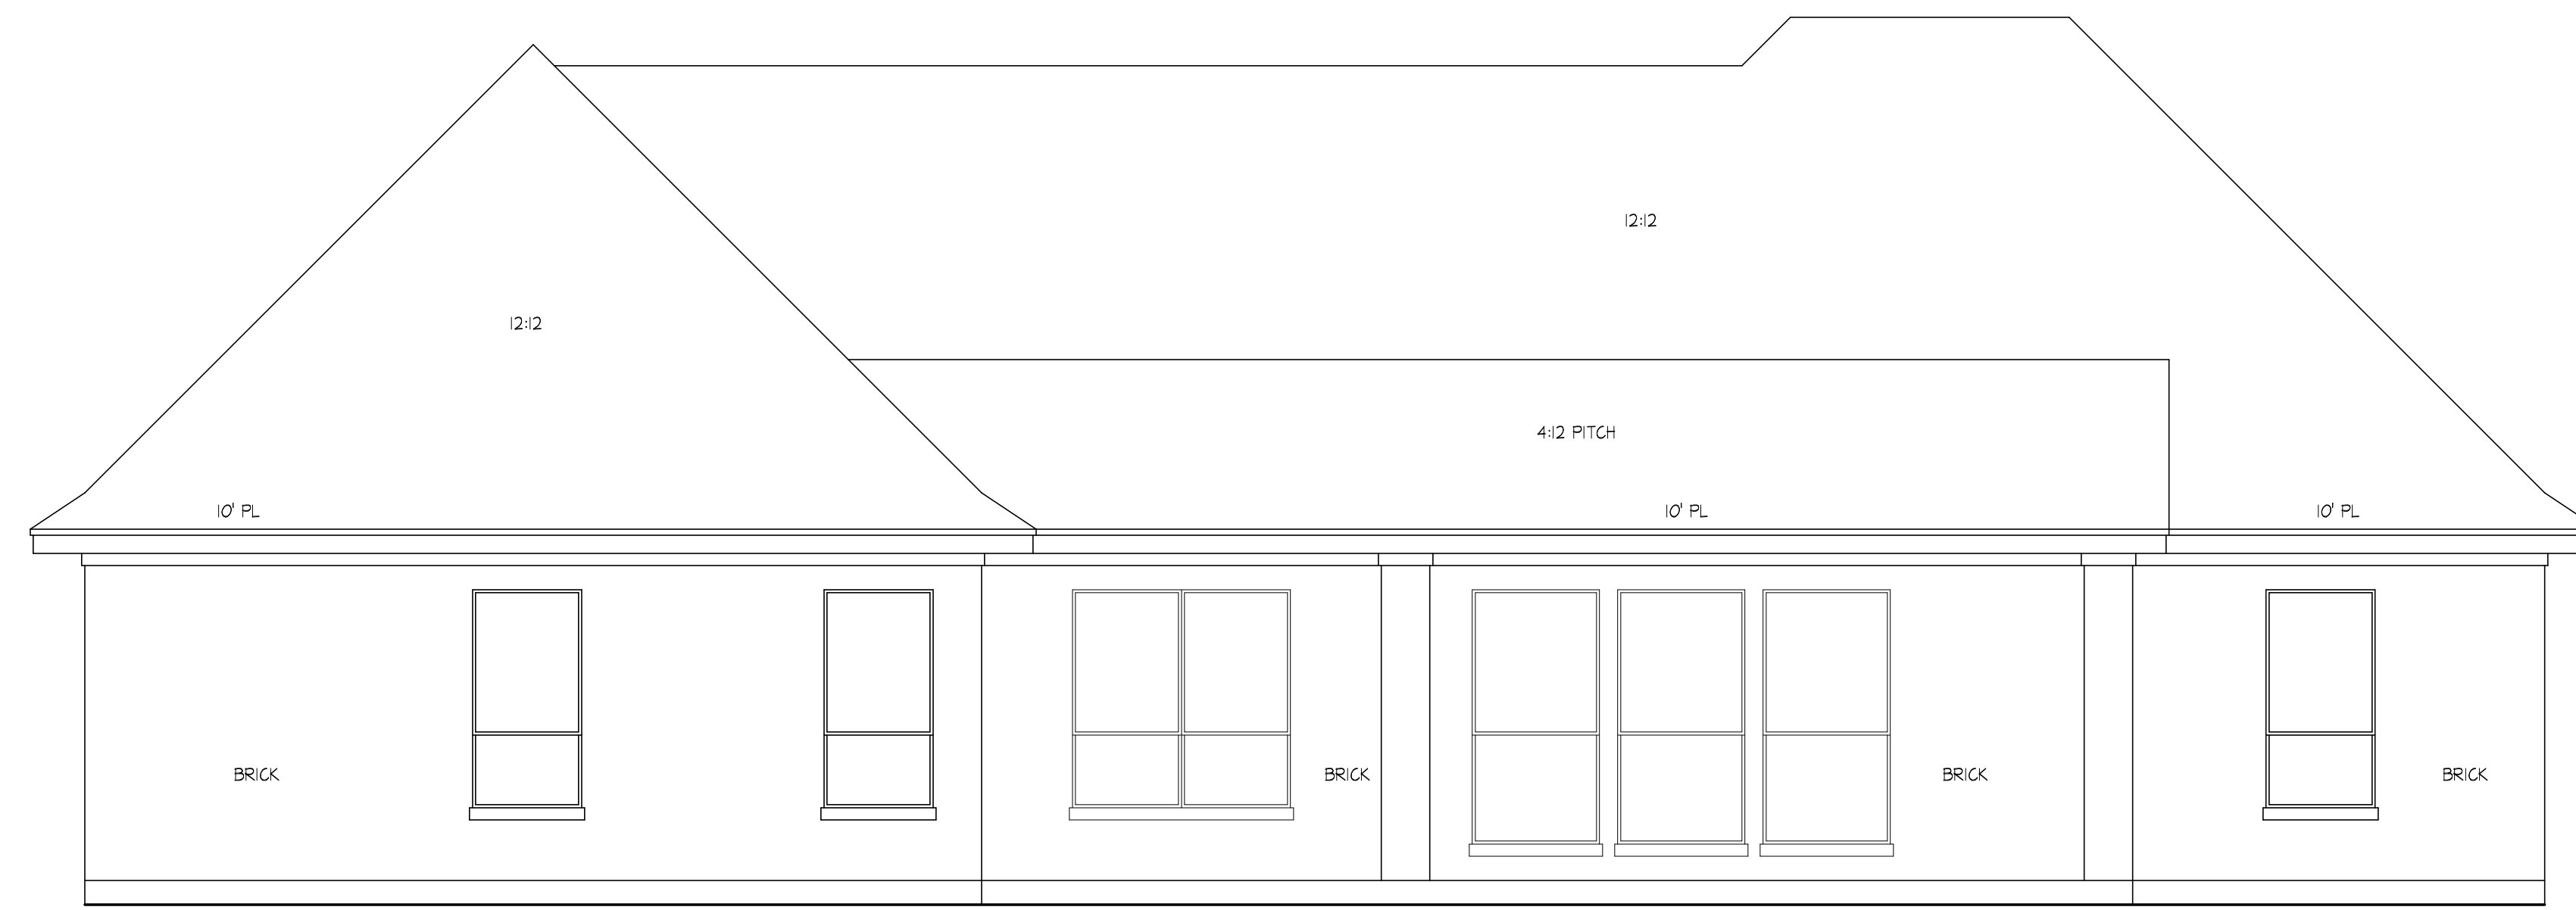


REAR ELEVATION

SCALE: 1/4"=1'-0"


NOTES:
These plans are not to be used without the written permission of J. THACKER CUSTOM HOME DESIGNS
SUITE 210, HURST, TX 76053
817-262-0654
It is the responsibility of the contractor to verify all dimensions, codes and easements.
Designs are liability not to exceed the plans on page.

R T B
CUSTOM HOMES
817-901-7963

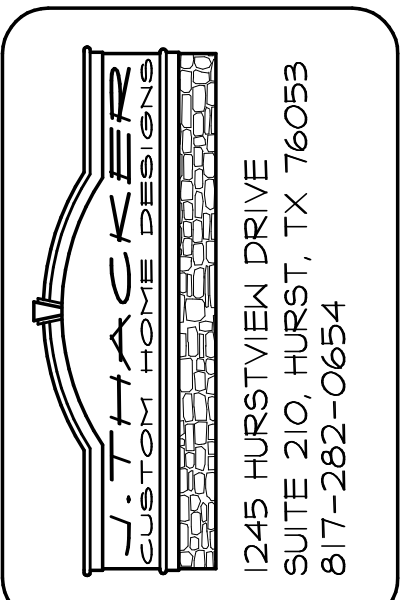


1245 HURSTVIEW DRIVE
SUITE 210, HURST, TX 76053
817-262-0654

PLAN NO.
03212201

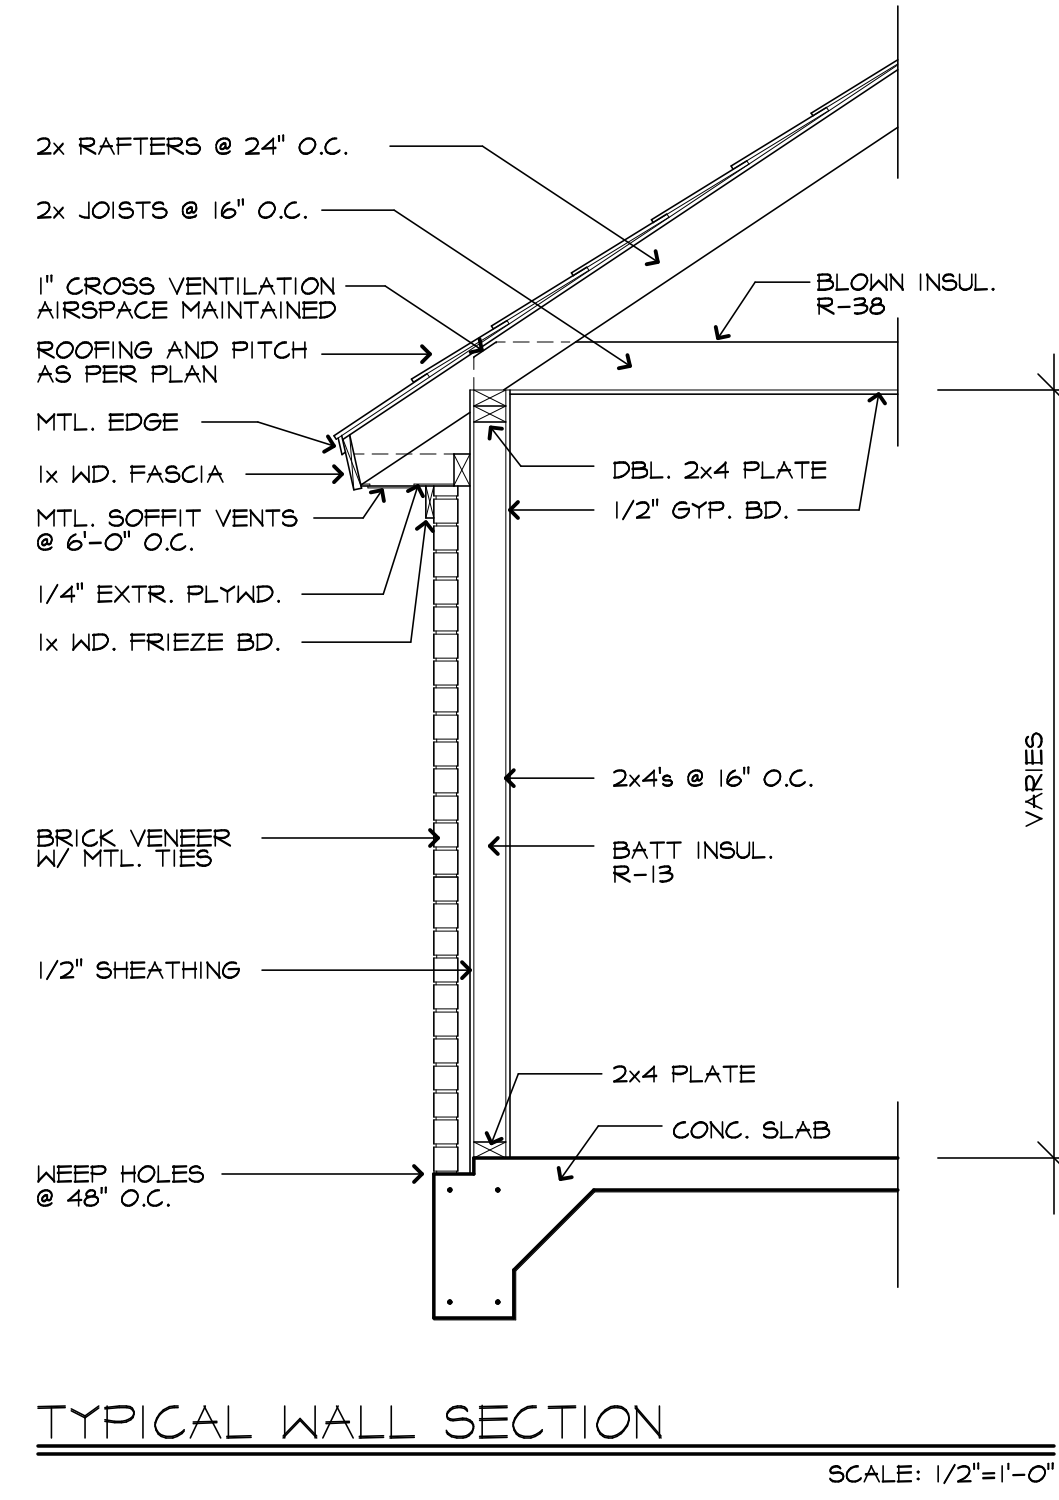

AREAS	SF
LIVING	2201
GARAGE	576
PORCH	75
COVD PATIO	372
TOTAL COVD AREA	3224

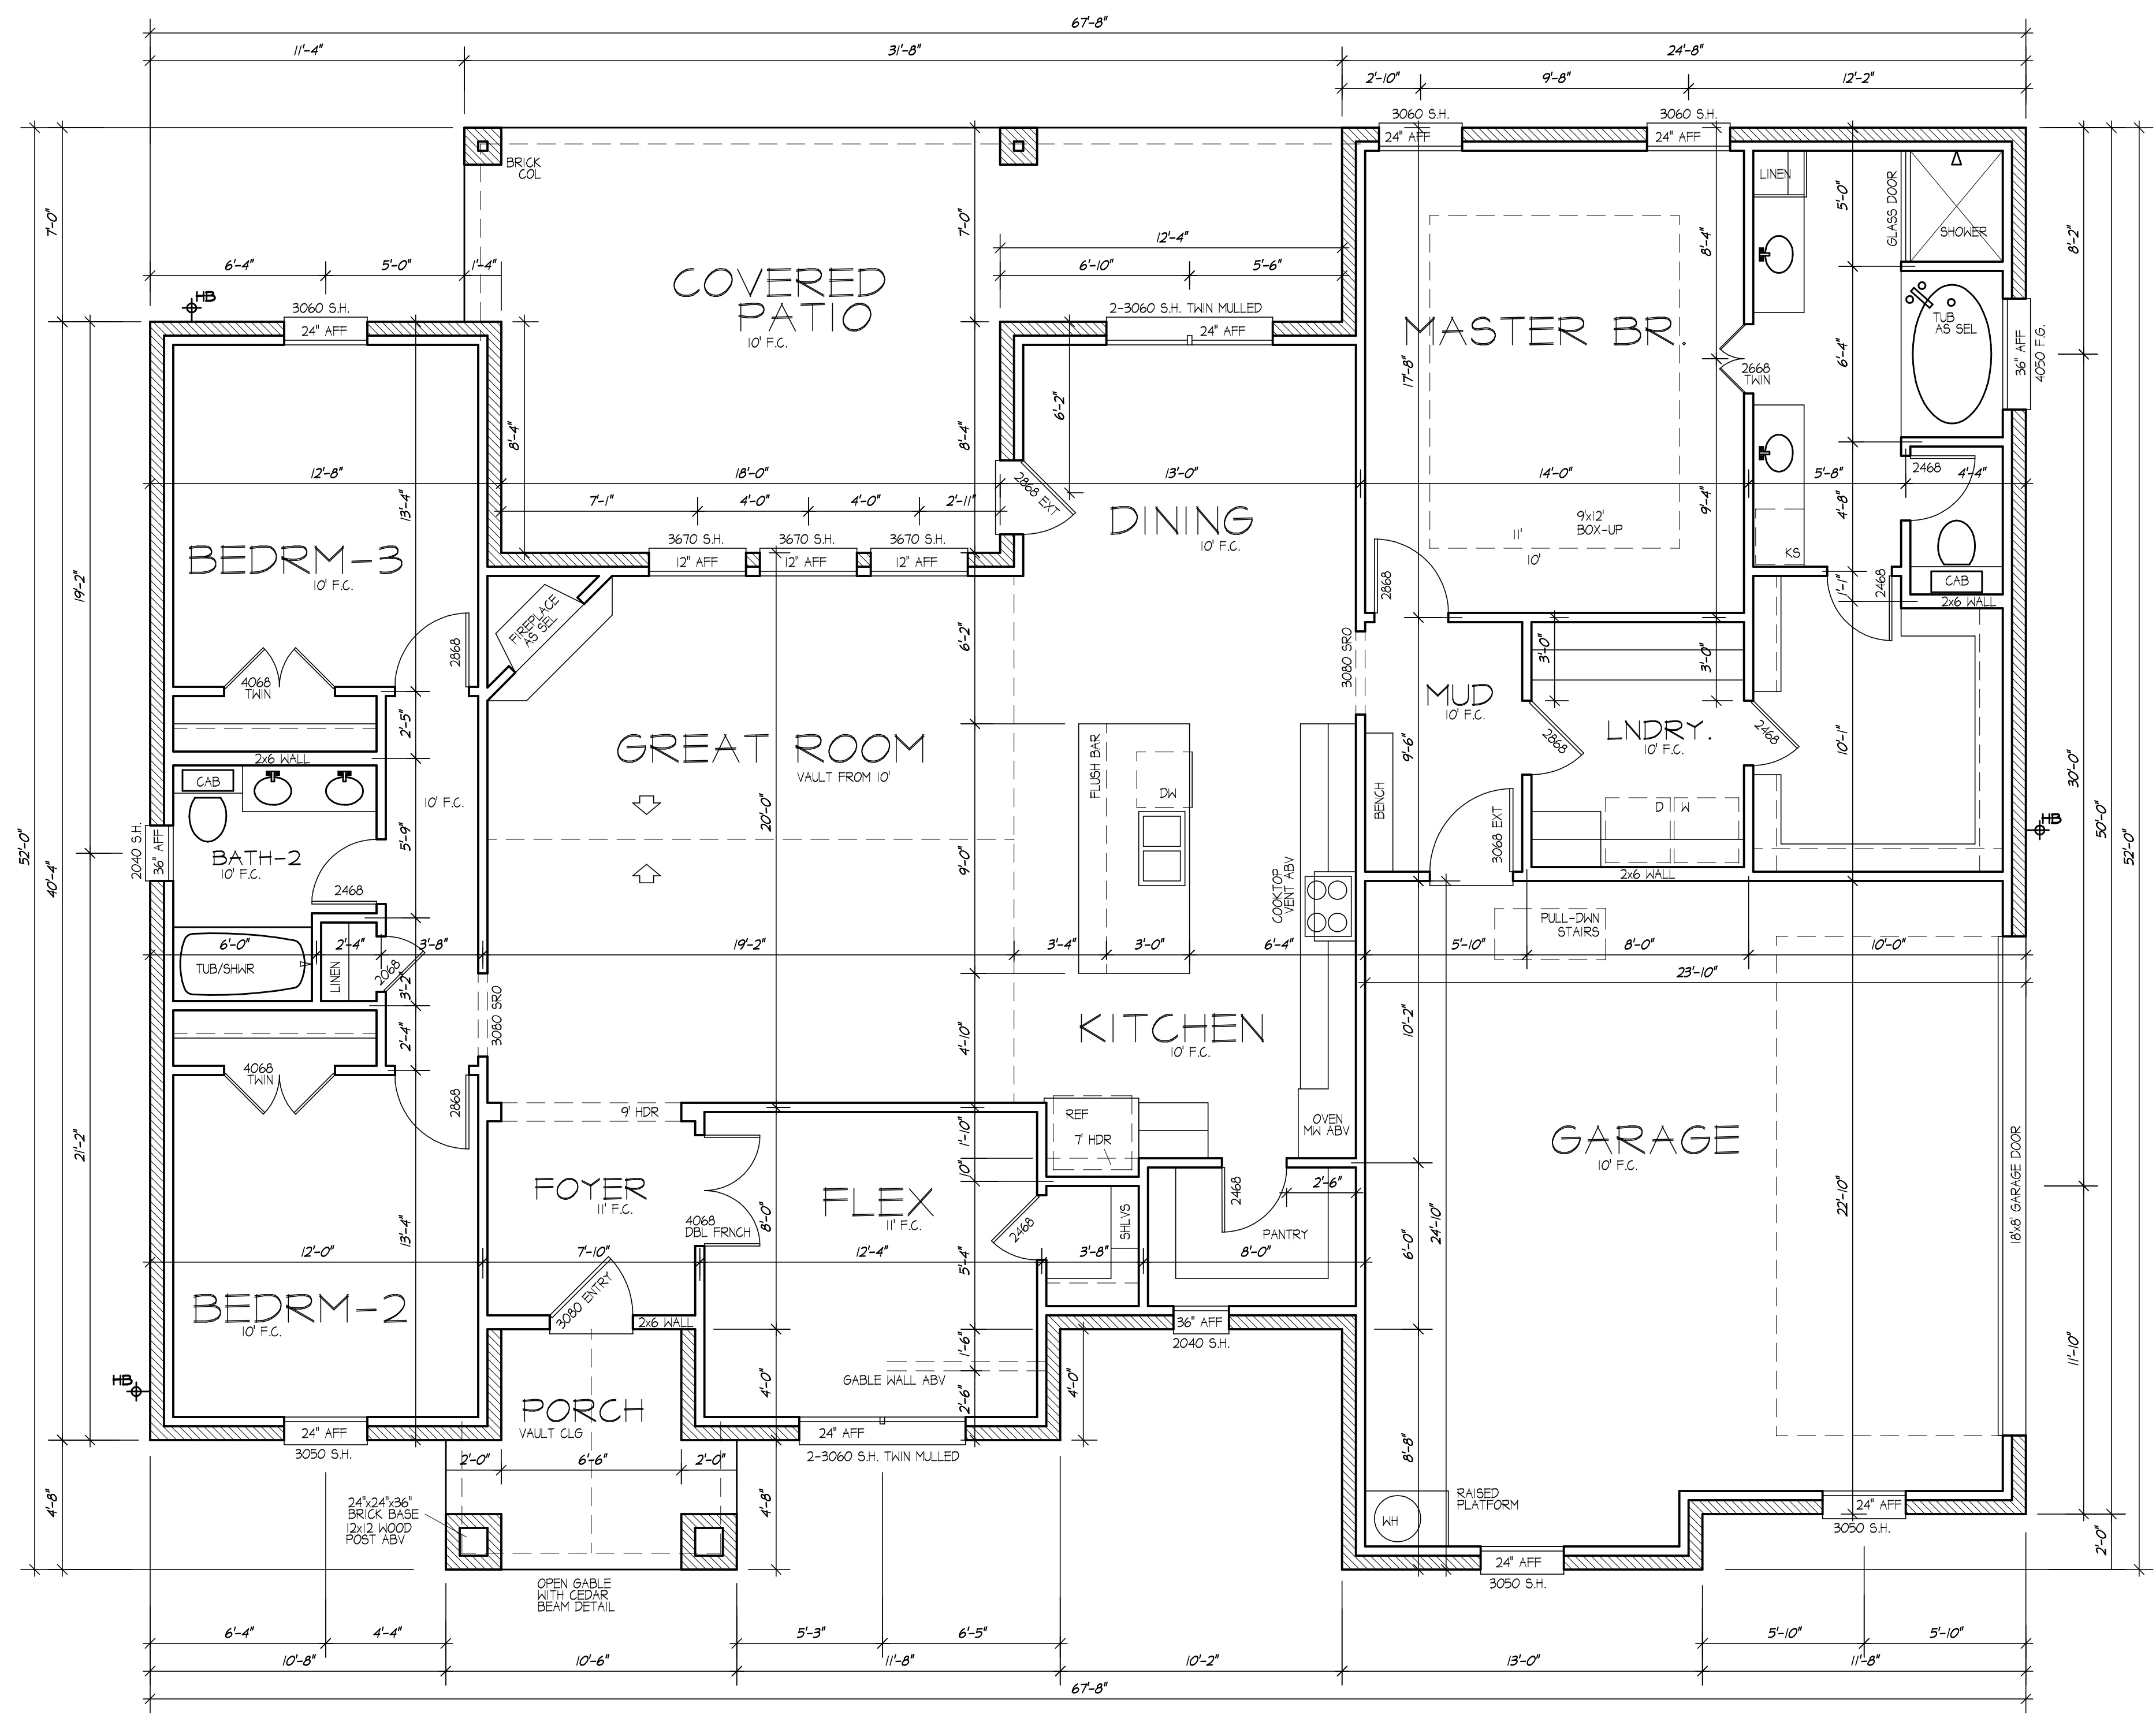

FLOOR PLAN


SCALE: 1/4"=1'-0"

NOTES:
 These Plans are not to be used for construction without the written permission of J. THACKER
 CUSTOM HOME DESIGNS
 SUITE 210, HURST, TX 76053
 817-262-0654
 It is the responsibility of the contractor to verify all dimensions and statements. All dimensions are in feet and inches. All dimensions are rounded to the nearest 1/8 inch. All dimensions are in feet and inches. All dimensions are rounded to the nearest 1/8 inch. All dimensions are in feet and inches. All dimensions are rounded to the nearest 1/8 inch.

R T B
 CUSTOM HOMES
 817-901-7963

J. THACKER
 1245 HURSTVIEW DRIVE
 SUITE 210, HURST, TX 76053
 817-262-0654

PLAN NO.
 03212201

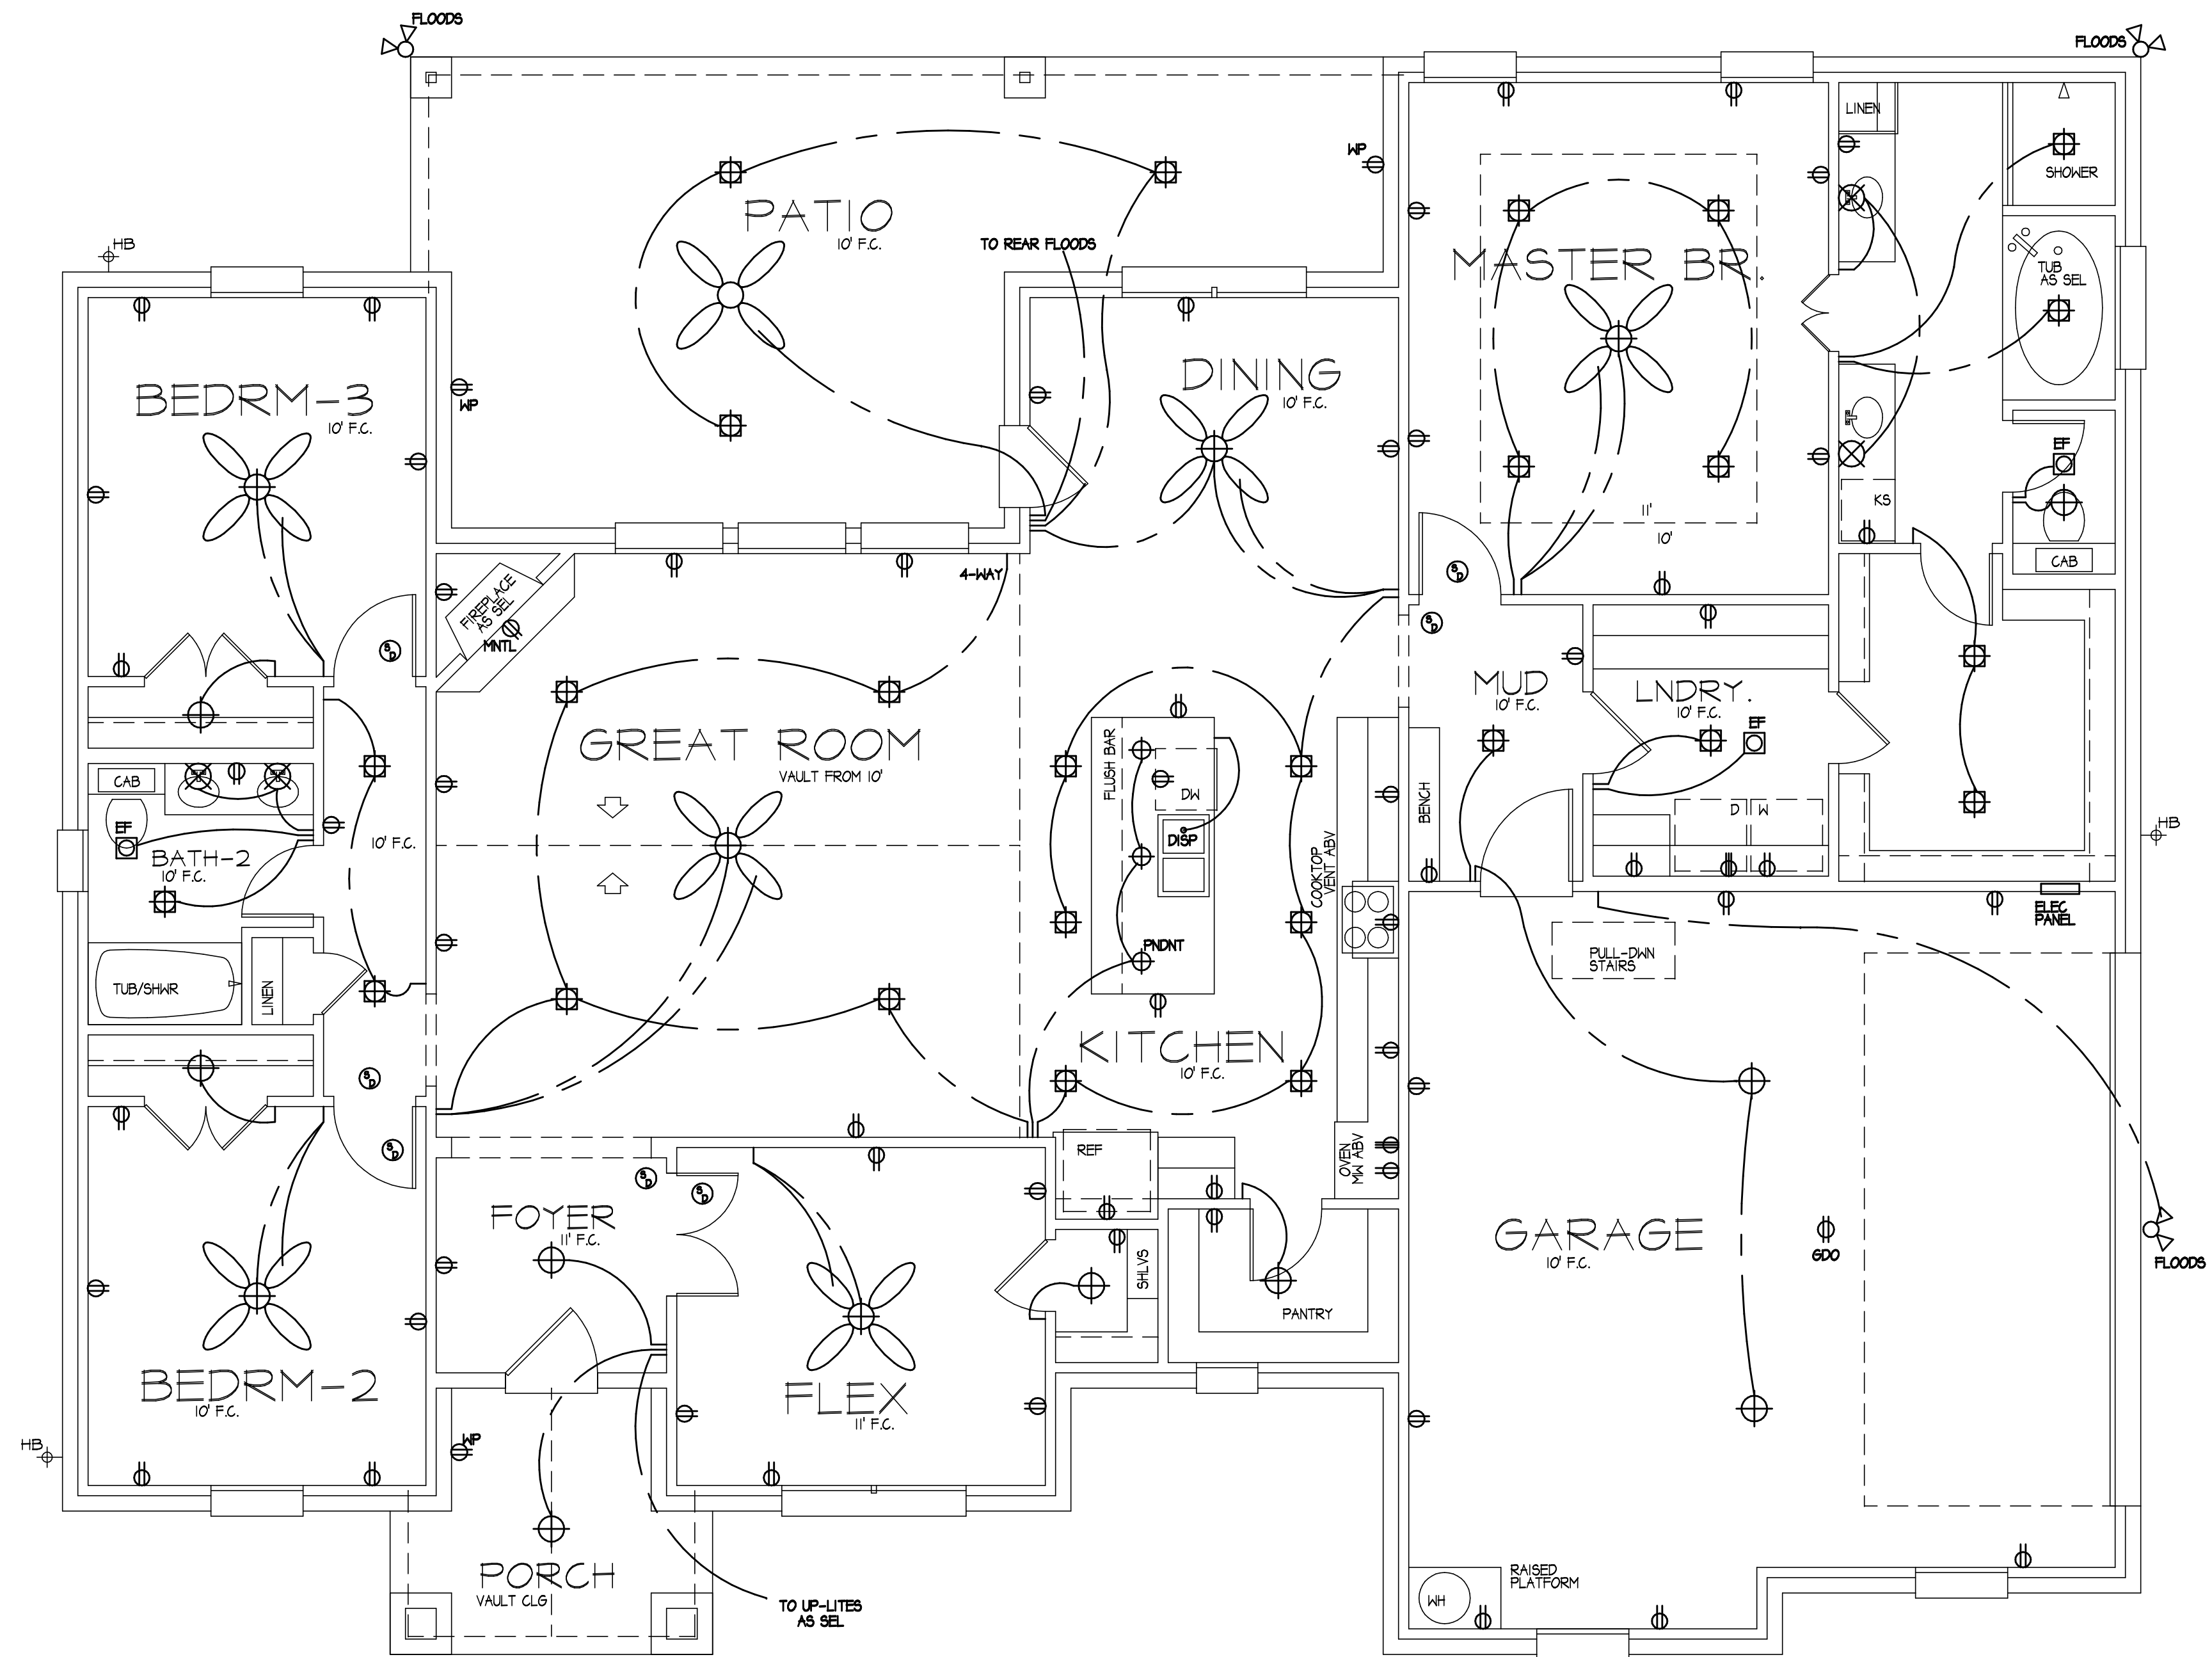

ELECTRICAL LAYOUT

VERIFY FLOOR PLUG LOCATIONS PRIOR TO SLAB POUR

SC: 1/4" = 1'-0"

NOTES:
 These plans are not to be used without the written permission of J. THACKER
 CUSTOM HOME DESIGNS
 SUITE 210, HURST, TX 76053
 It is the responsibility of the contractor to verify all dimensions, codes and statements. The designer's liability is not to exceed the price for plans.

R T B
 CUSTOM HOMES
 817-901-7963

J. THACKER
 1245 HURSTVIEW DRIVE
 SUITE 210, HURST, TX 76053
 817-262-0654

PLAN NO.
 03212201