


NOTES:
 These plans are not to be reproduced or revised without the written consent of the author.
 J. THACKER
 CUSTOM HOME DESIGNS
 SUITE 210, HURST, TX 76053
 817-282-0654
 It is the responsibility of the contractor to verify all dimensions, codes and statements on floor plans.
 Designer's liability not to exceed the cost of plans.

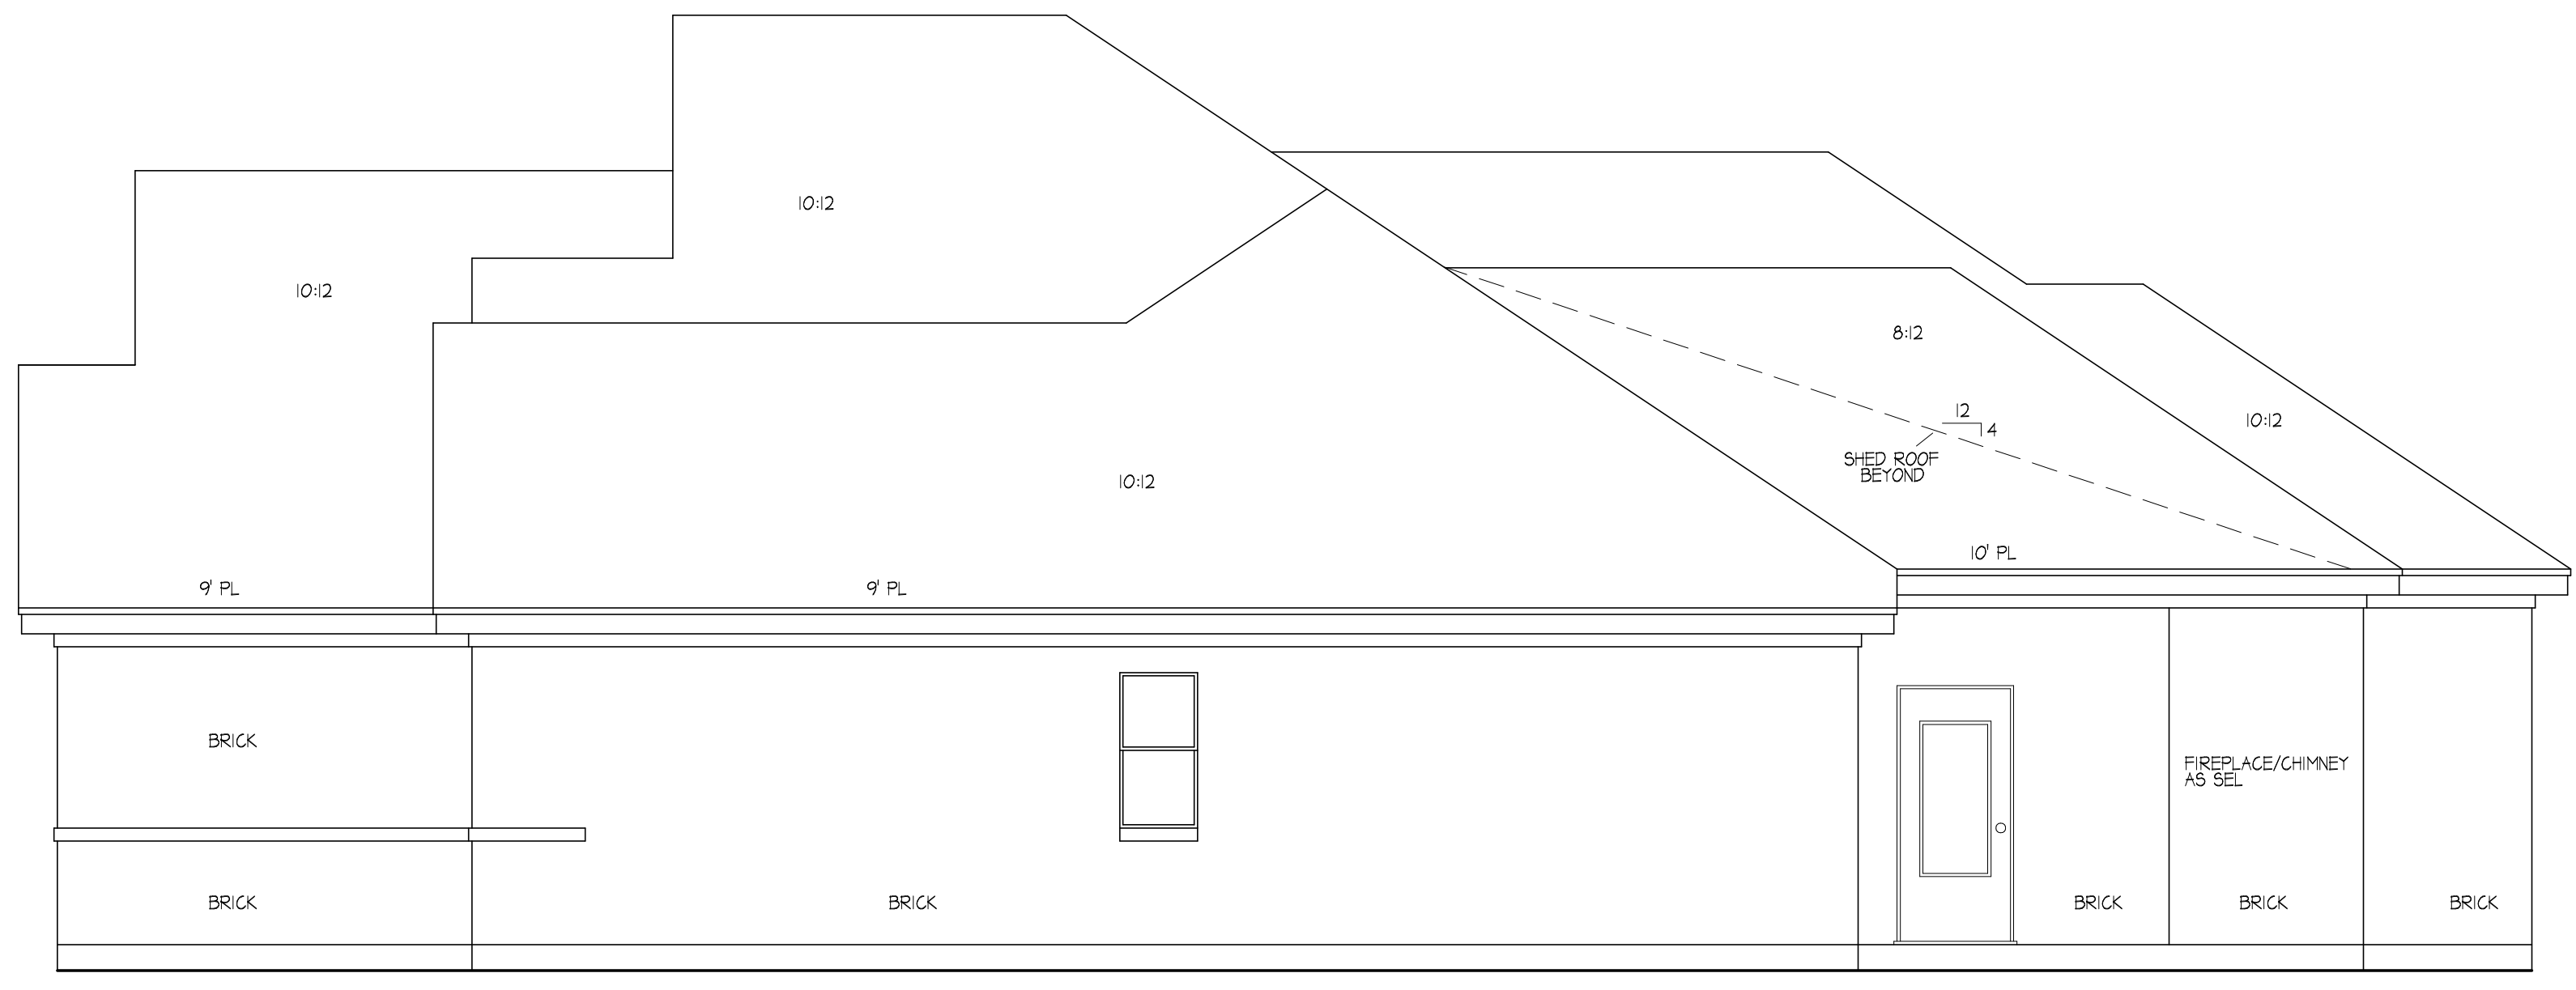

RIGHT SIDE

SC:1/4"=1'-0"




FRONT ELEVATION

SC:1/4"=1'-0"


R T B
 CUSTOM HOMES
 817-9901-7963

J. THACKER
 CUSTOM HOME DESIGNS
 1245 HURSTVIEW DRIVE
 SUITE 210, HURST, TX 76053
 817-282-0654


PLAN NO.
 08212466

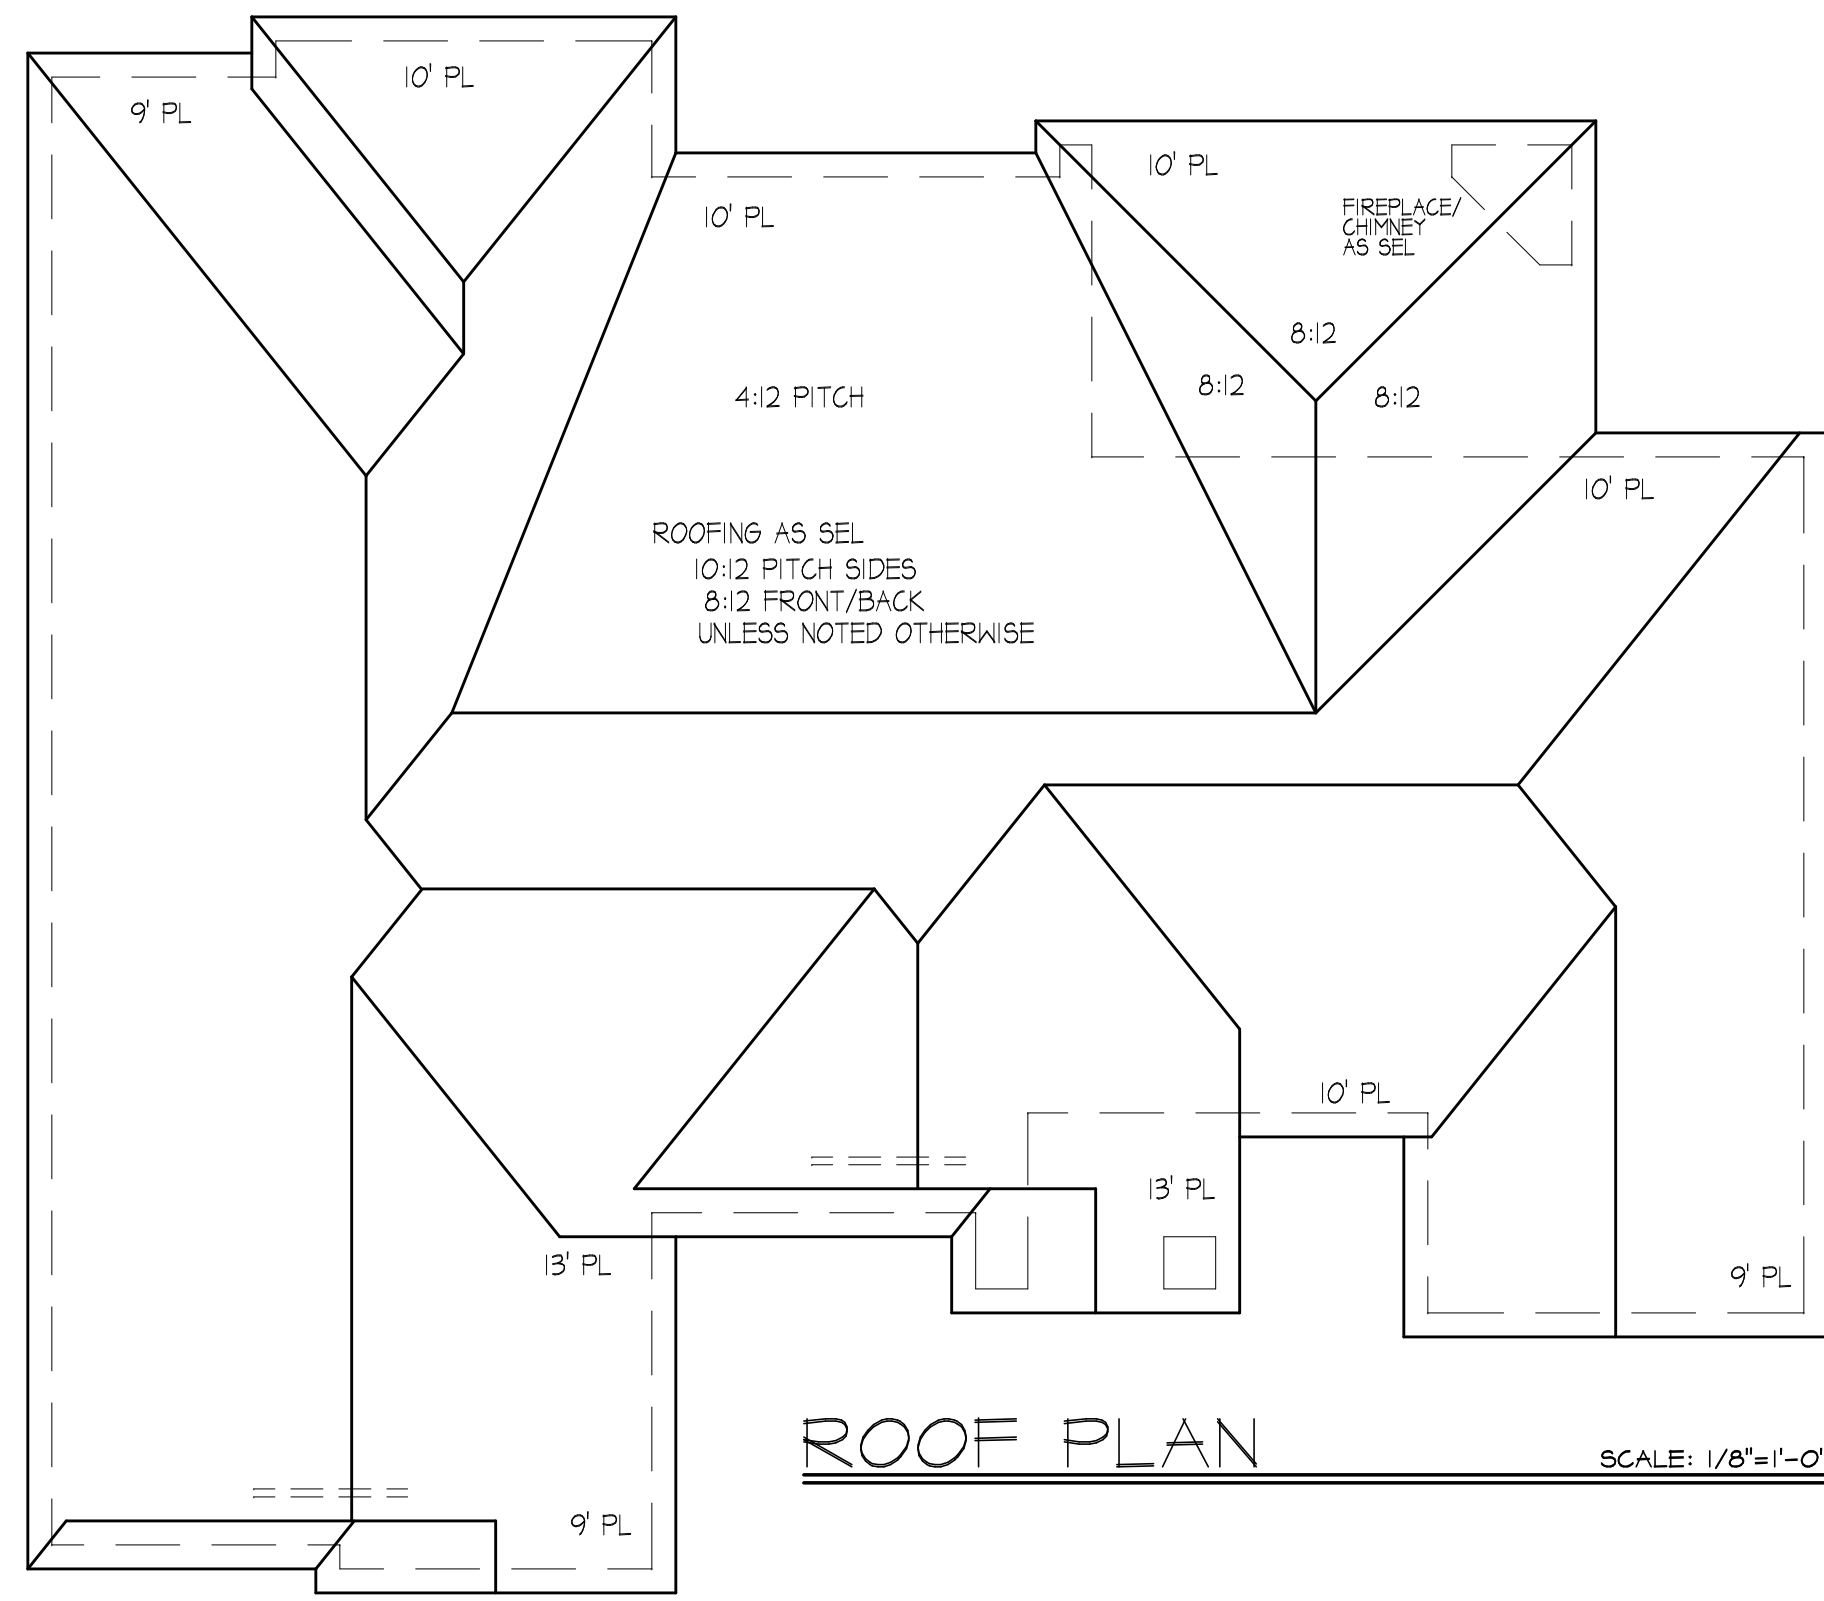

ROOF PLAN SCALE: 1/8"=1'-0"

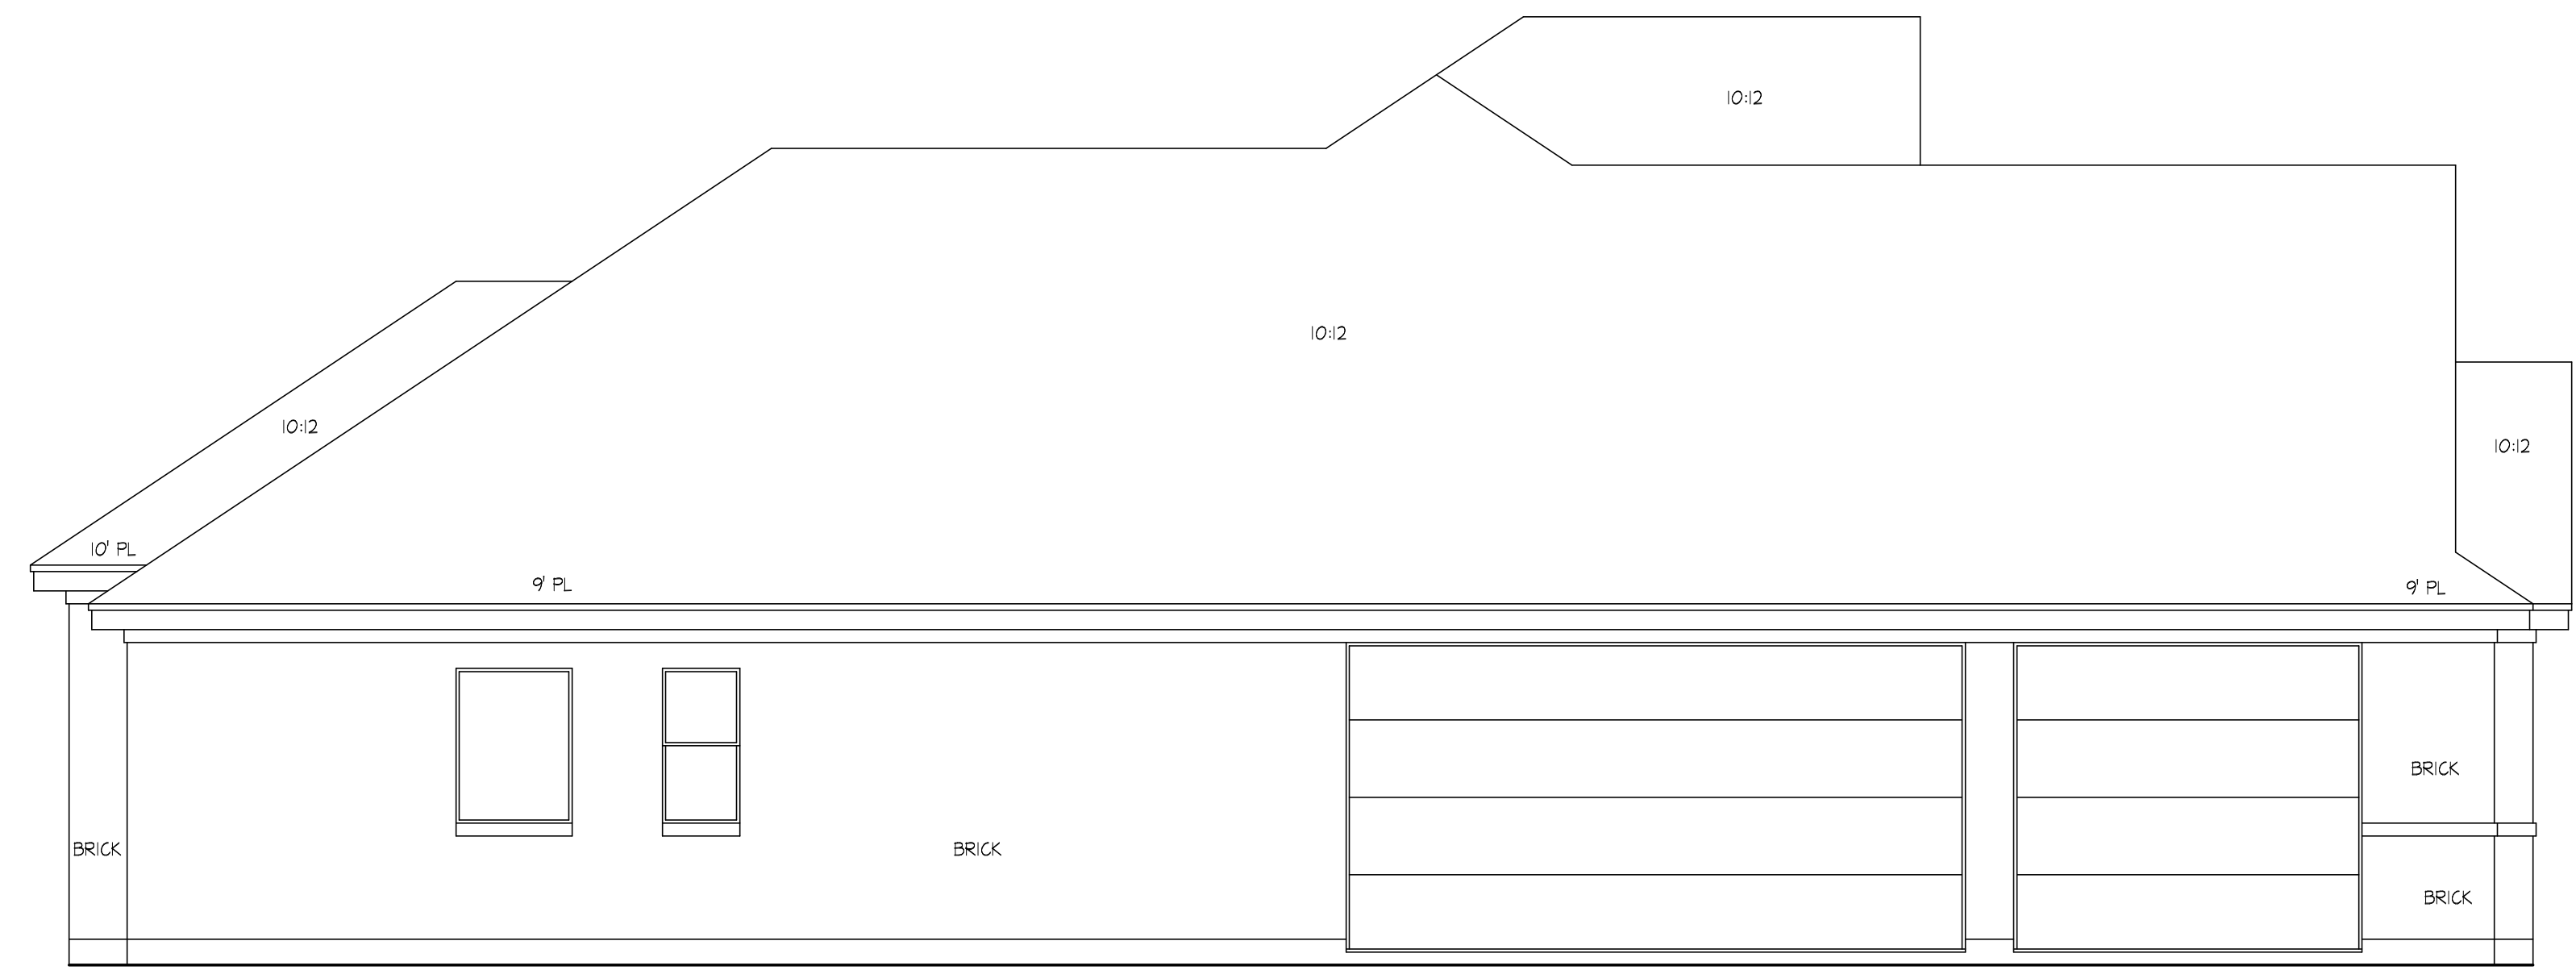

LEFT SIDE SCALE: 1/4"=1'-0"

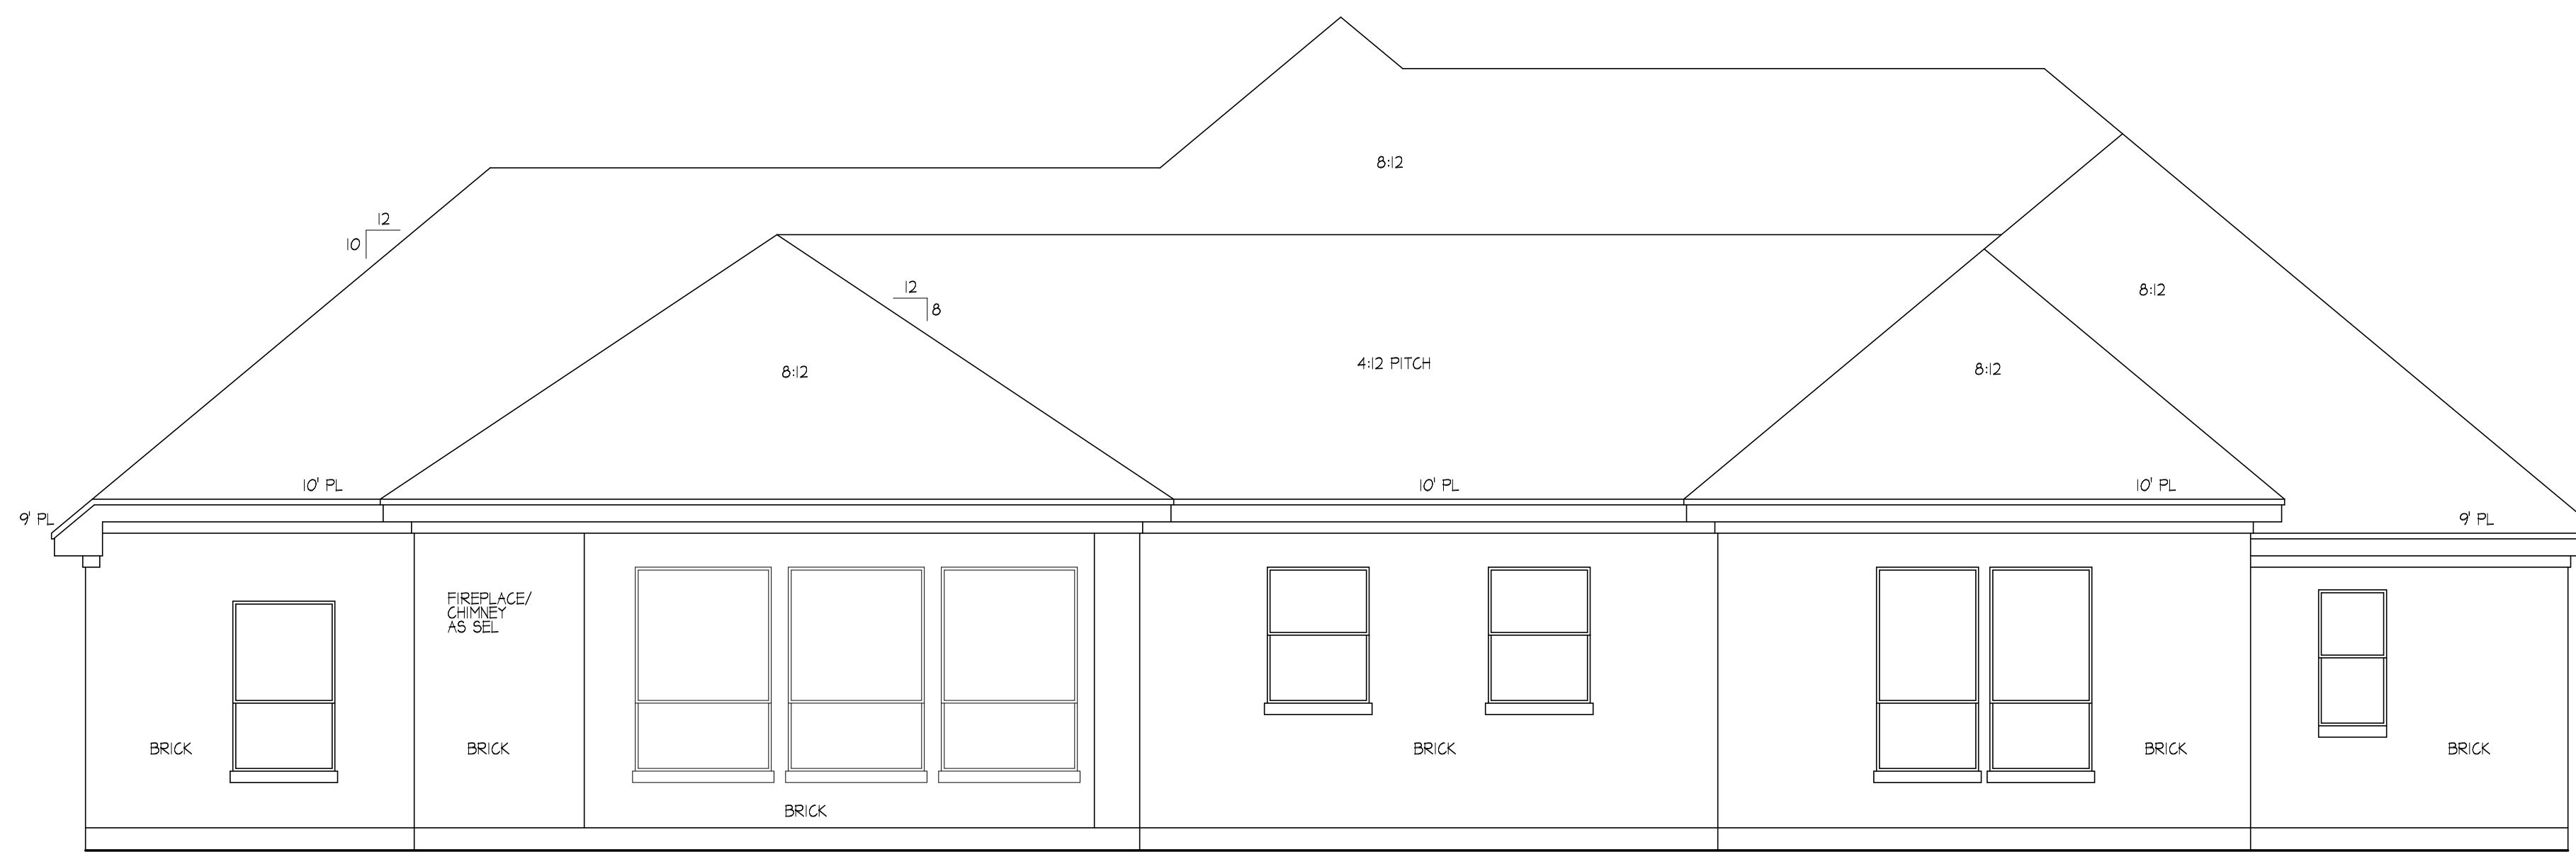


REAR ELEVATION SCALE: 1/4"=1'-0"

NOTES:
 These plans are not to be reproduced or reused without the written permission of J. THACKER
 CUSTOM HOME DESIGNS
 SUITE 210, HURST, TX 76053
 817-282-0654
 It is the responsibility of the contractor to verify all dimensions and elevations with local codes and ordinances.
 Designer's liability not to exceed the foot for plans.

R T B
CUSTOM HOMES
 817-901-7963

J. THACKER
 CUSTOM HOME DESIGNS
 1245 HURSTVIEW DRIVE
 SUITE 210, HURST, TX 76053
 817-282-0654


PLAN NO.
 08212466

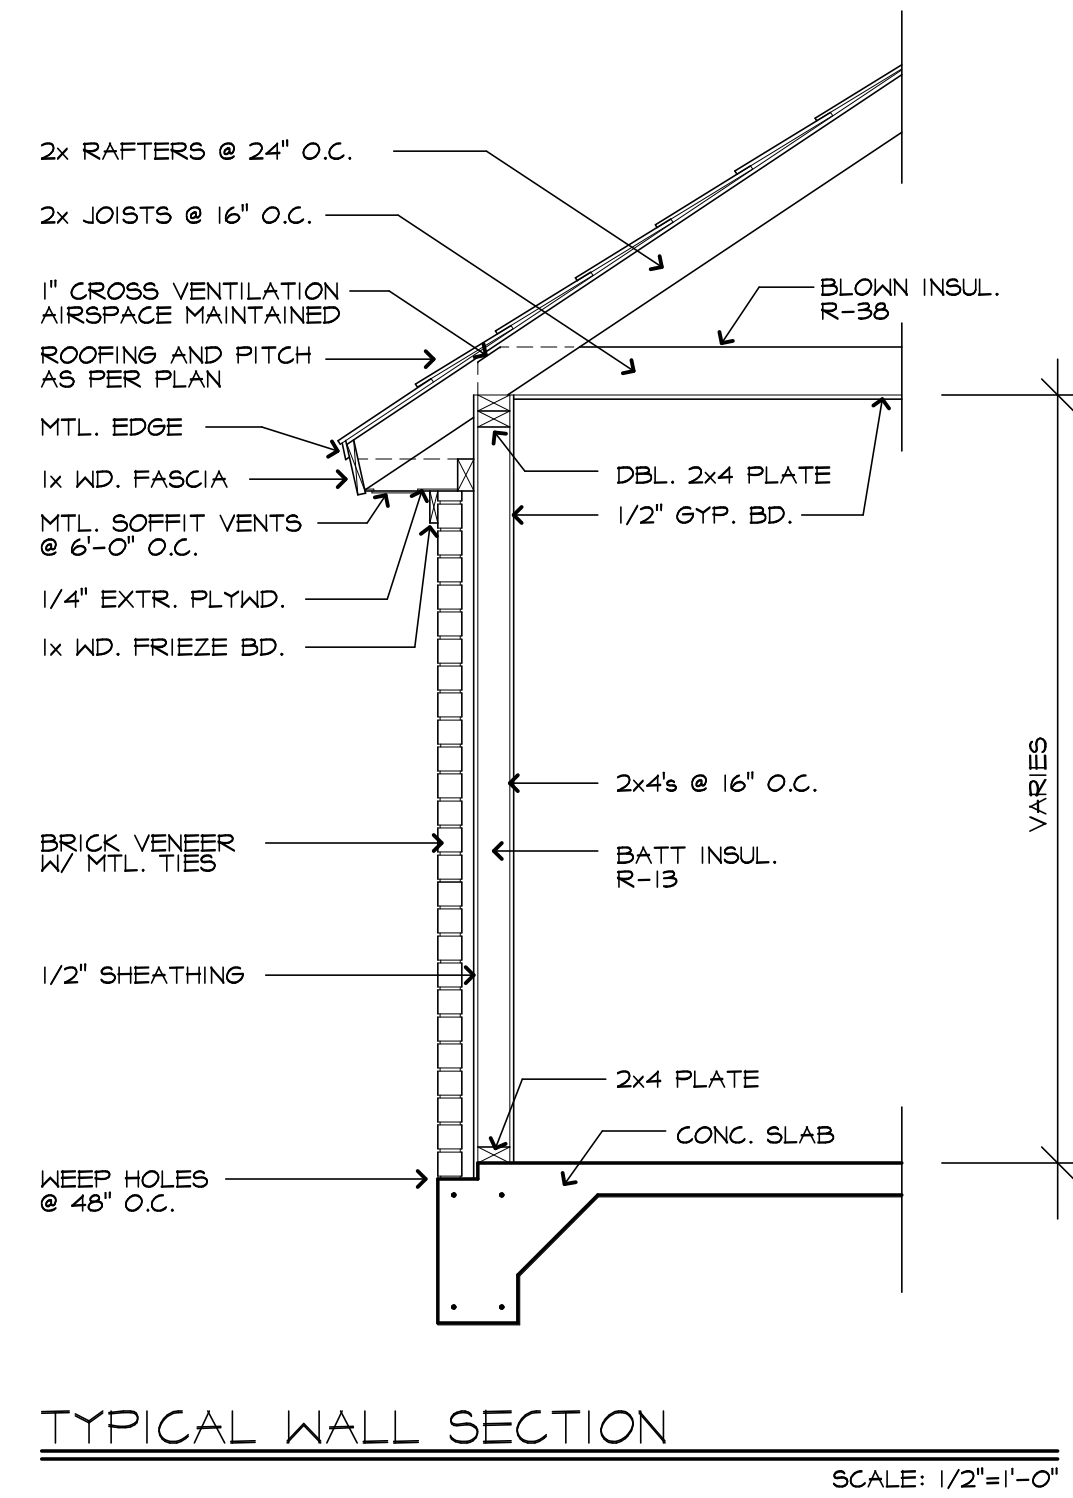

TYPICAL WALL SECTION

SCALE: 1/2"=1'-0"

AREAS	SF
LIVING	2466
GARAGE	822
PORCH	64
COVD PATIO	262
TOTAL COVD AREA	3614

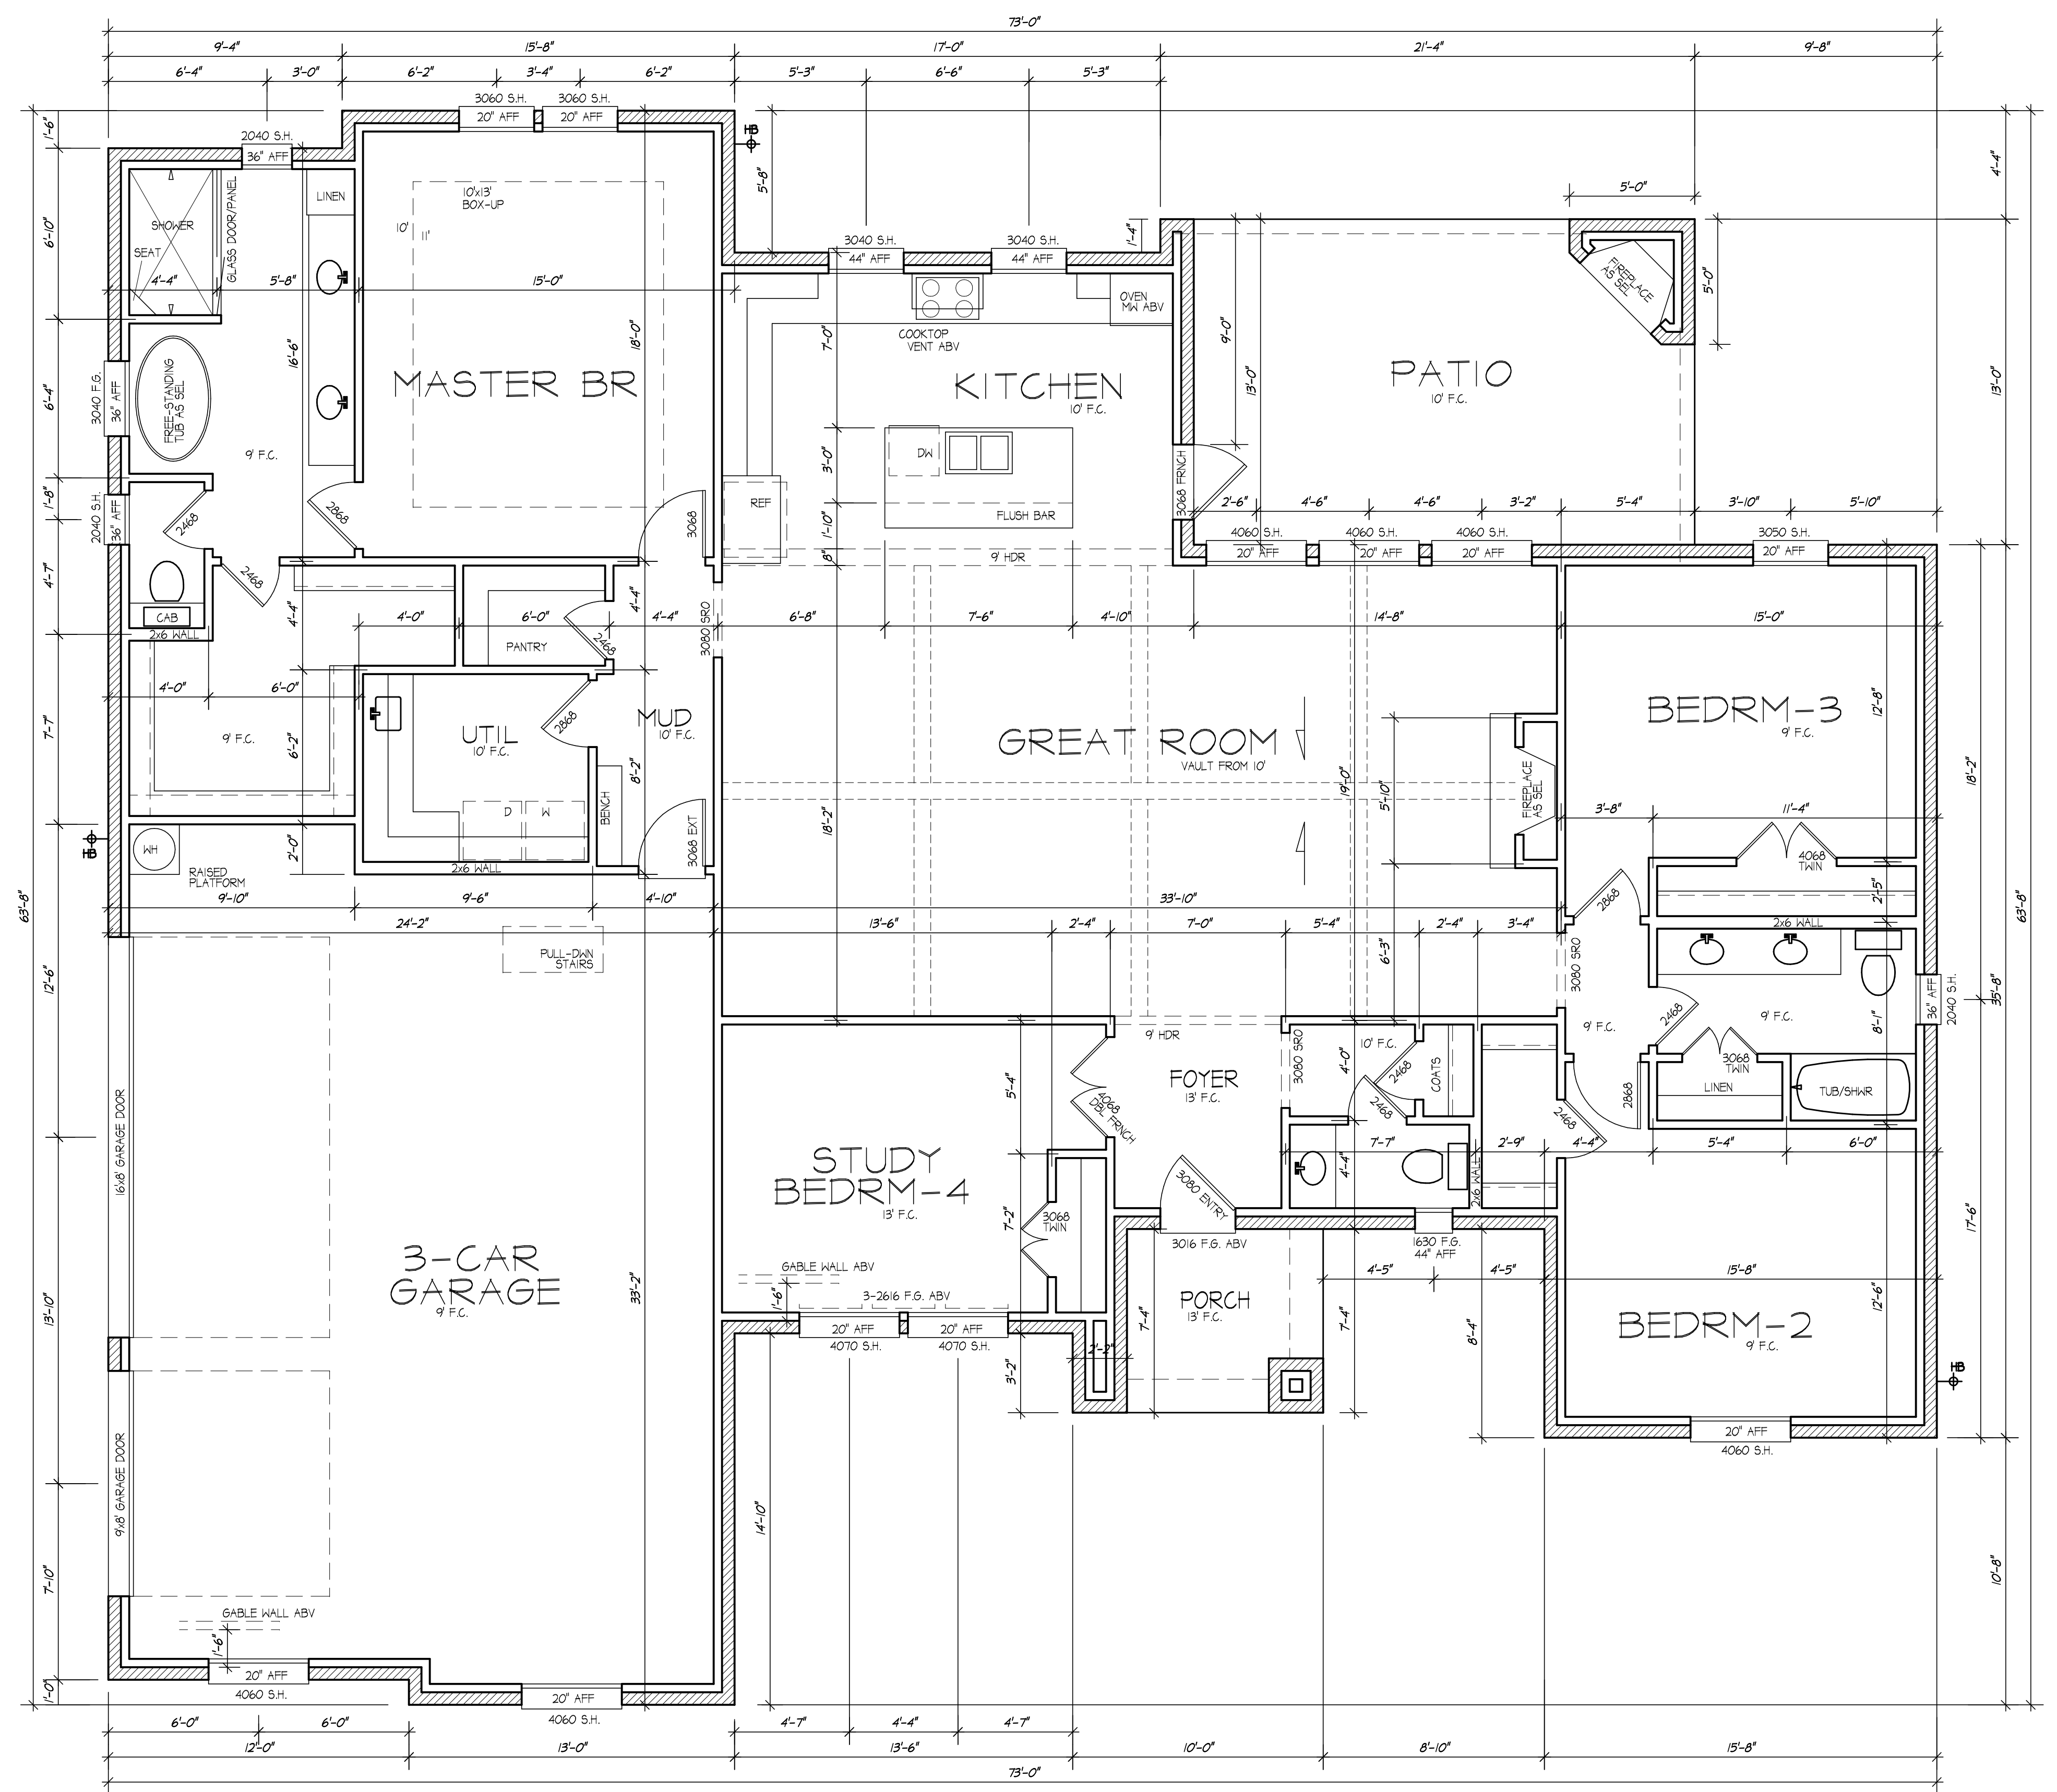

FLOOR PLAN


SCALE: 1/4"=1'-0"

NOTES:
 These plans are not to be used without the written permission of J. THACKER
 CUSTOM HOME DESIGNS
 SUITE 210, HURST, TX 76053
 It is the responsibility of the contractor to verify all dimensions, codes and statements. The designer's liability shall not exceed the price of plans.

R T B
 CUSTOM HOMES
 817-901-7963

1245 HURSTVIEW DRIVE
 SUITE 210, HURST, TX 76053
 817-262-0654

PLAN NO.
 08212466

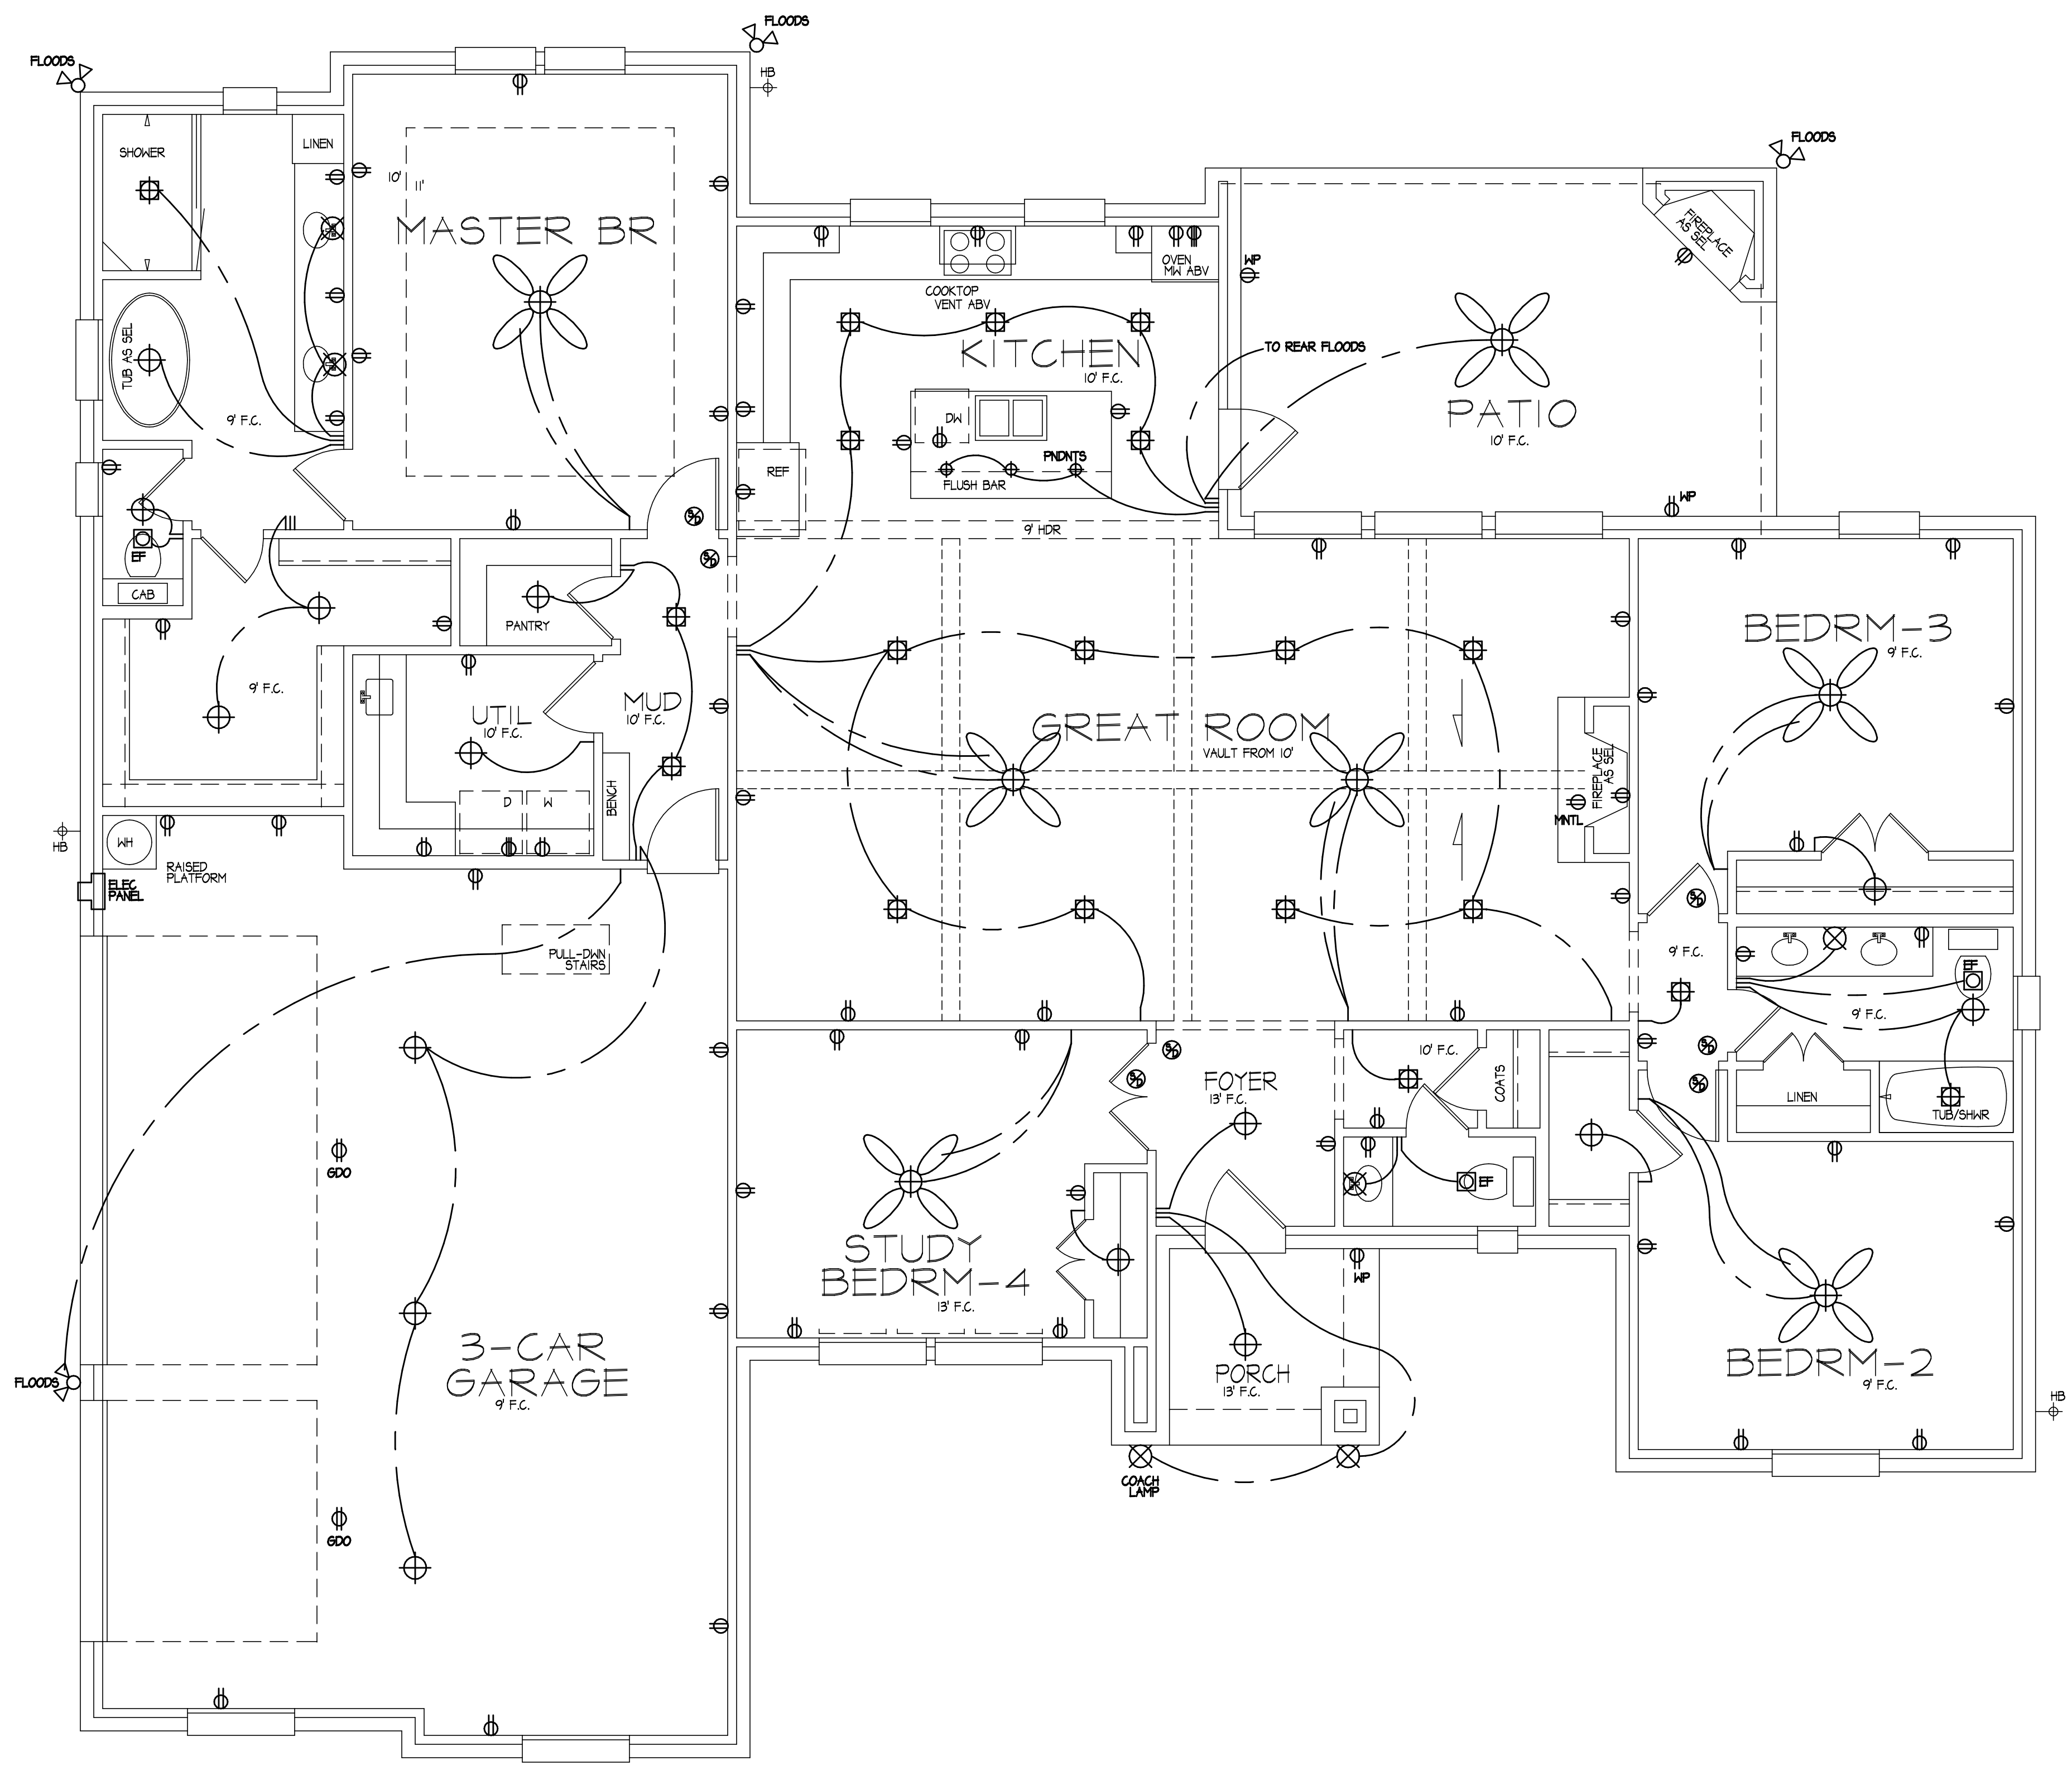

ELECTRICAL LAYOUT

SC: 1/4" = 1'-0"

NOTES:
 These plans are not to be used without the written permission of J. THACKER
 CUSTOM HOME DESIGNS
 SUITE 210, HURST, TX 76053
 It is the responsibility of the contractor to verify all dimensions, codes and statements. All electrical designs are subject to change without notice.
 Designer's liability not to exceed the price of plans.

R T B
 CUSTOM HOMES
 817-901-7963

J. THACKER
 1245 HURSTVIEW DRIVE
 SUITE 210, HURST, TX 76053
 817-262-0654

PLAN NO.
 02202455